



DATE	BY

PLAN	SURVEYED	PLOTTED	CHECKED

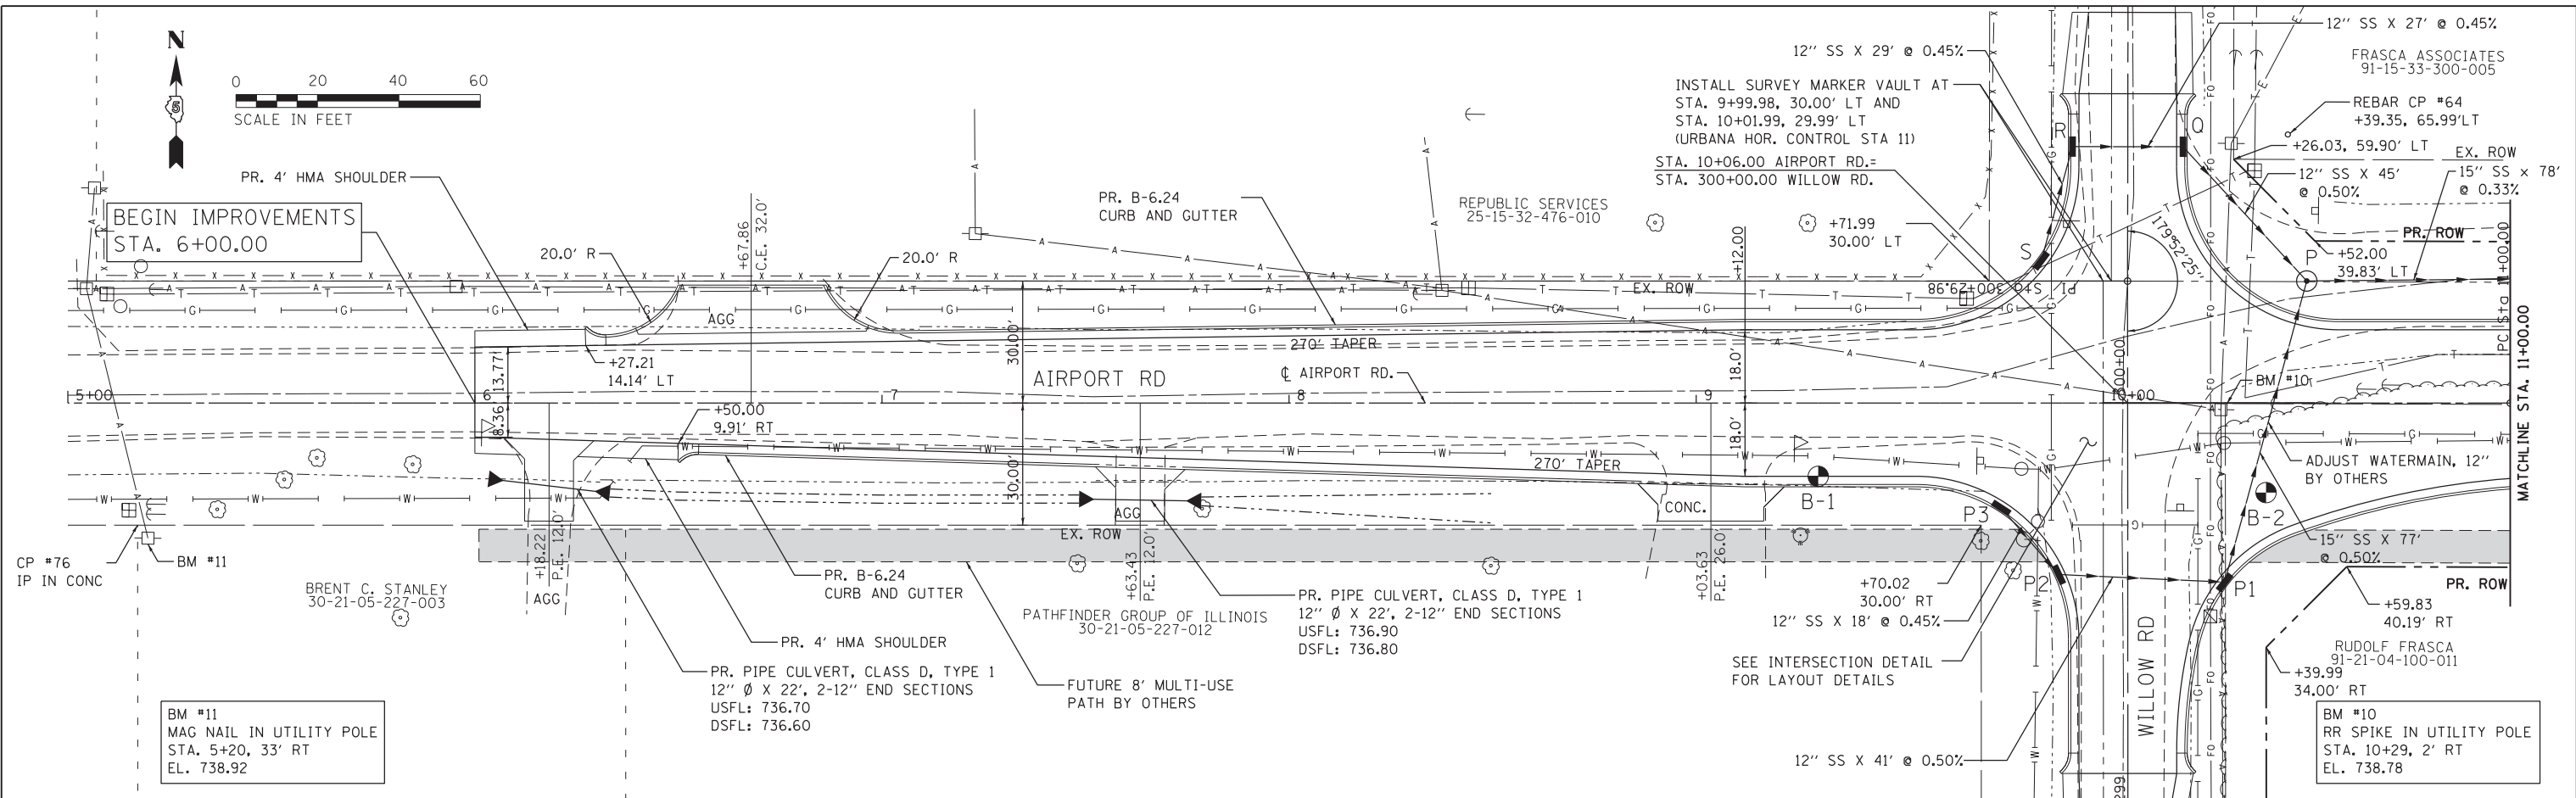

DATE	BY

PROFILE	SURVEYED	GRADES CHECKED	STRUCTURE	NOTATIONS CHKD

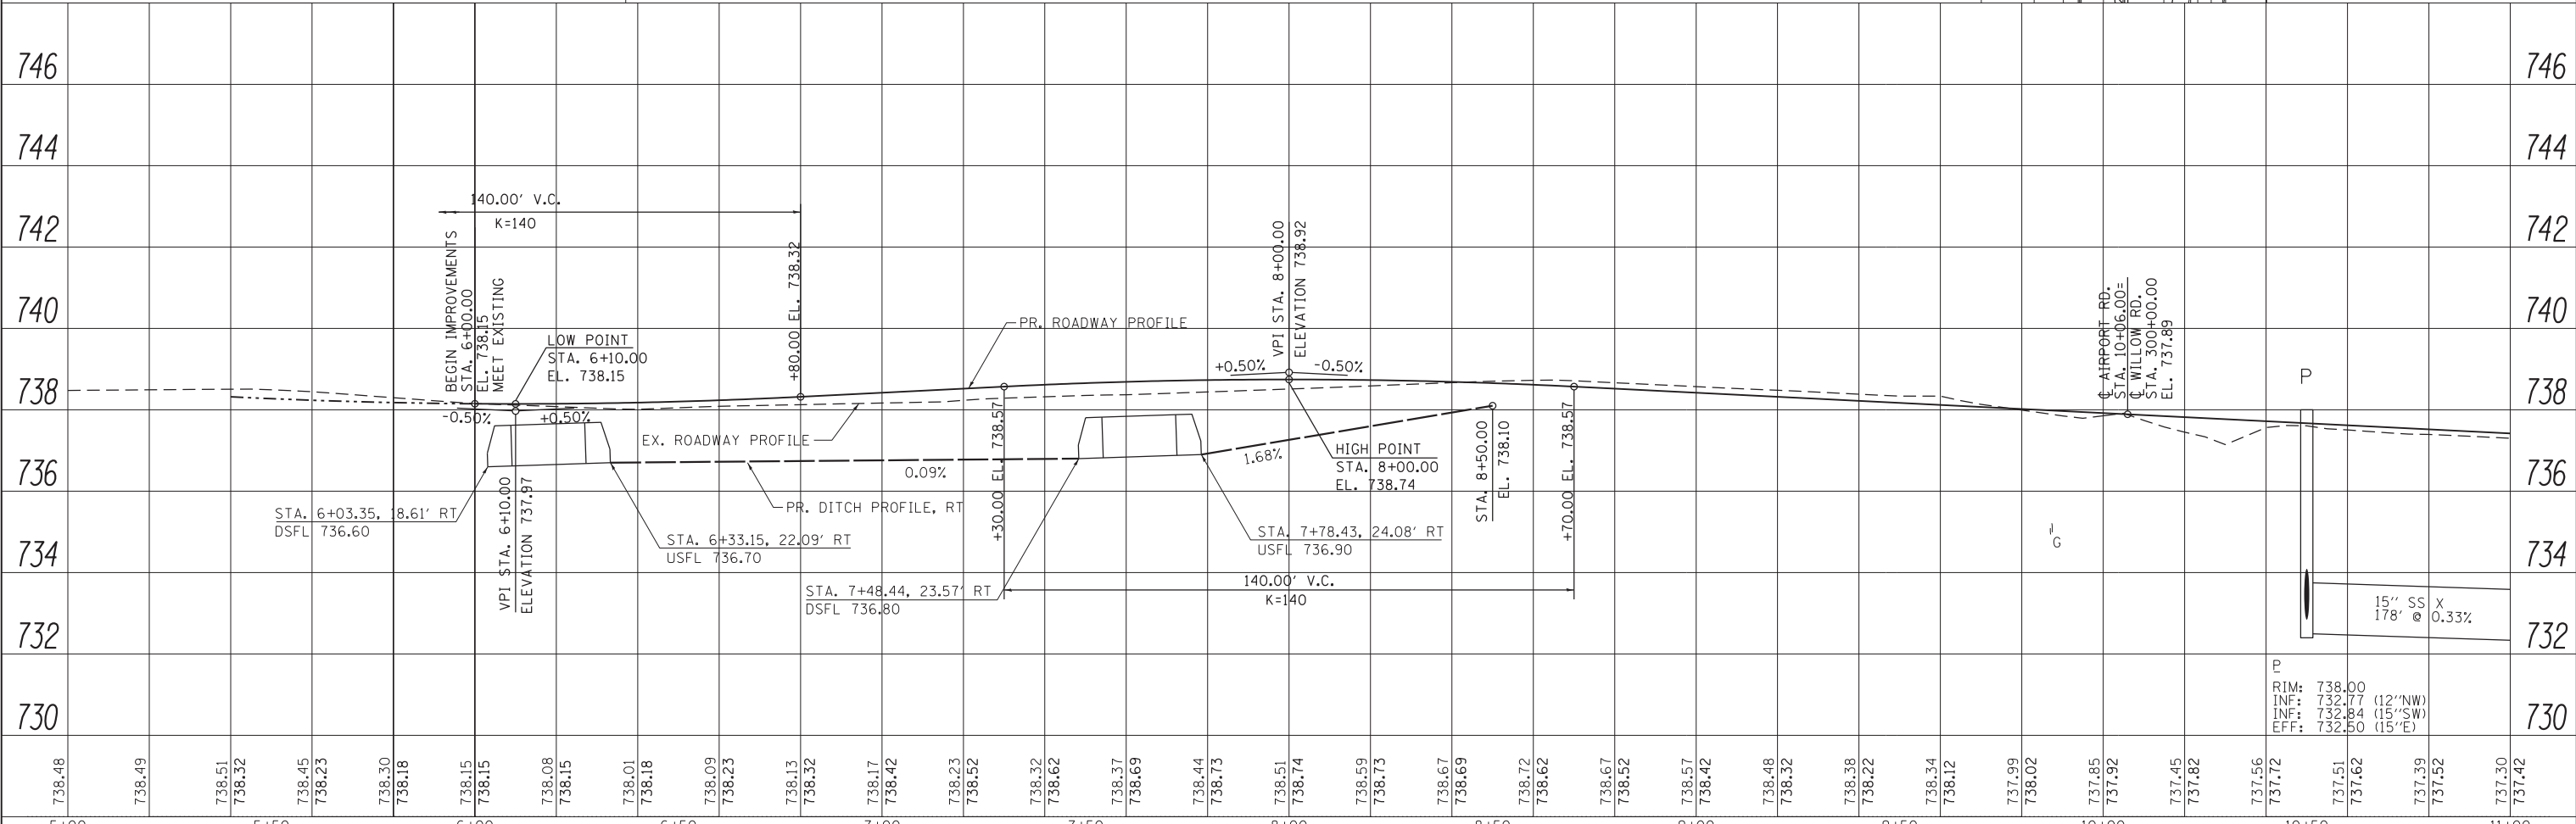

Farnsworth
GROUP, INC.
2211 West Bradley Avenue
Champaign, Illinois 61821
217/352-7408, 217/352-7409 fax

USER NAME = slisenby	DESIGNED - DSC	REVISED -
PRINTER = \$SYS PRINTER_NAME\$	DRAWN - JDJ	REVISED -
PLOT SCALE = 20.0000' / in.	CHECKED - JLF	REVISED -
PLOT DATE = 3/17/2017	DATE - 01/26/2017	REVISED -


STATE OF ILLINOIS
DEPARTMENT OF TRANSPORTATION

PLAN AND PROFILE - AIRPORT ROAD

SCALE: 1" = 20' SHEET NO. 1 OF 8 SHEETS STA. 5+00.00 TO STA. 11+00.00

F.A.U. RTE.	SECTION	COUNTY	TOTAL SHEETS	SHEET NO.
7190	13-00532-00-PV	CHAMPAIGN	80	19


CONTRACT NO.
ILLINOIS FED. AID PROJECT

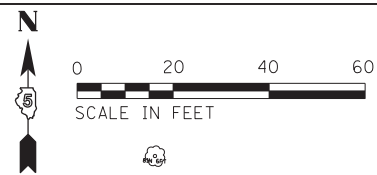


FRASCA ASSOCIATES
91-15-33-300-005

FRASCA ASSOCIATES
91-15-33-300-005

PLAN	SURVEYED	DATE
	PLOTTED	BY
	CHECKED	
	ALIGNED	
	FILED	
	NO. CAD FILE NAME	

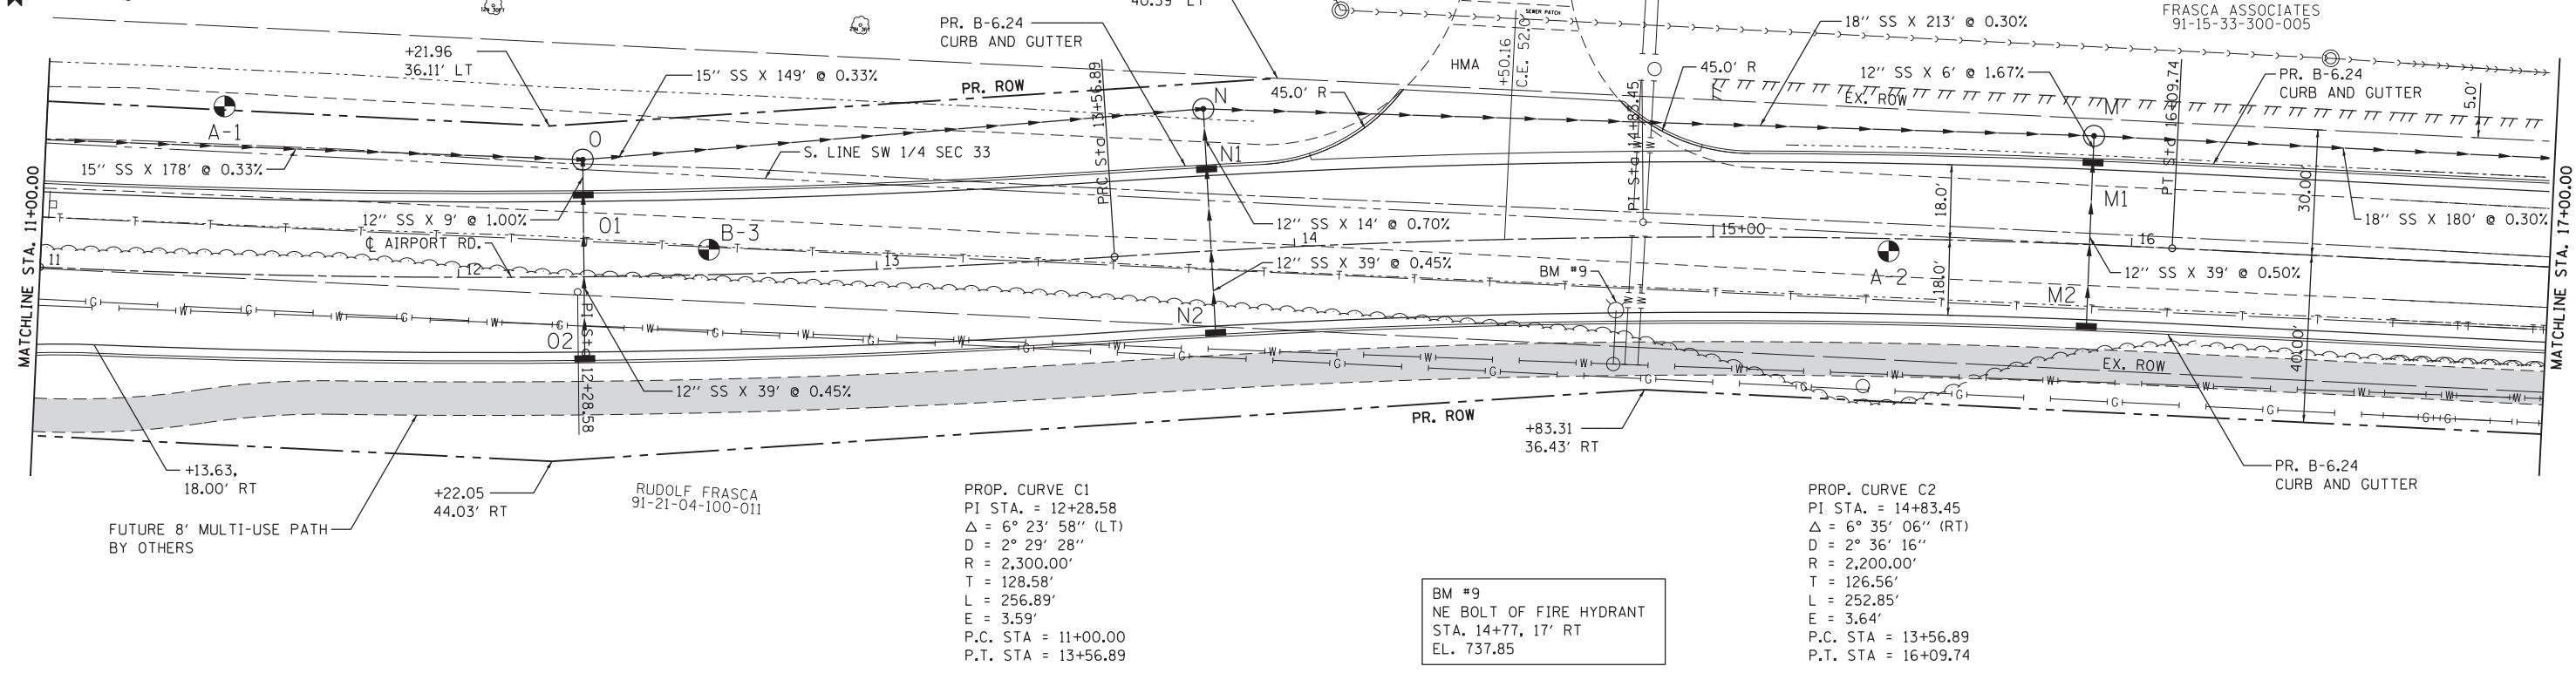

PROFILE	SURVEYED	DATE
	PLOTTED	BY
	CHECKED	
	GRADES	
	STRUCTURE	
	NOTATIONS	
	CHKD	

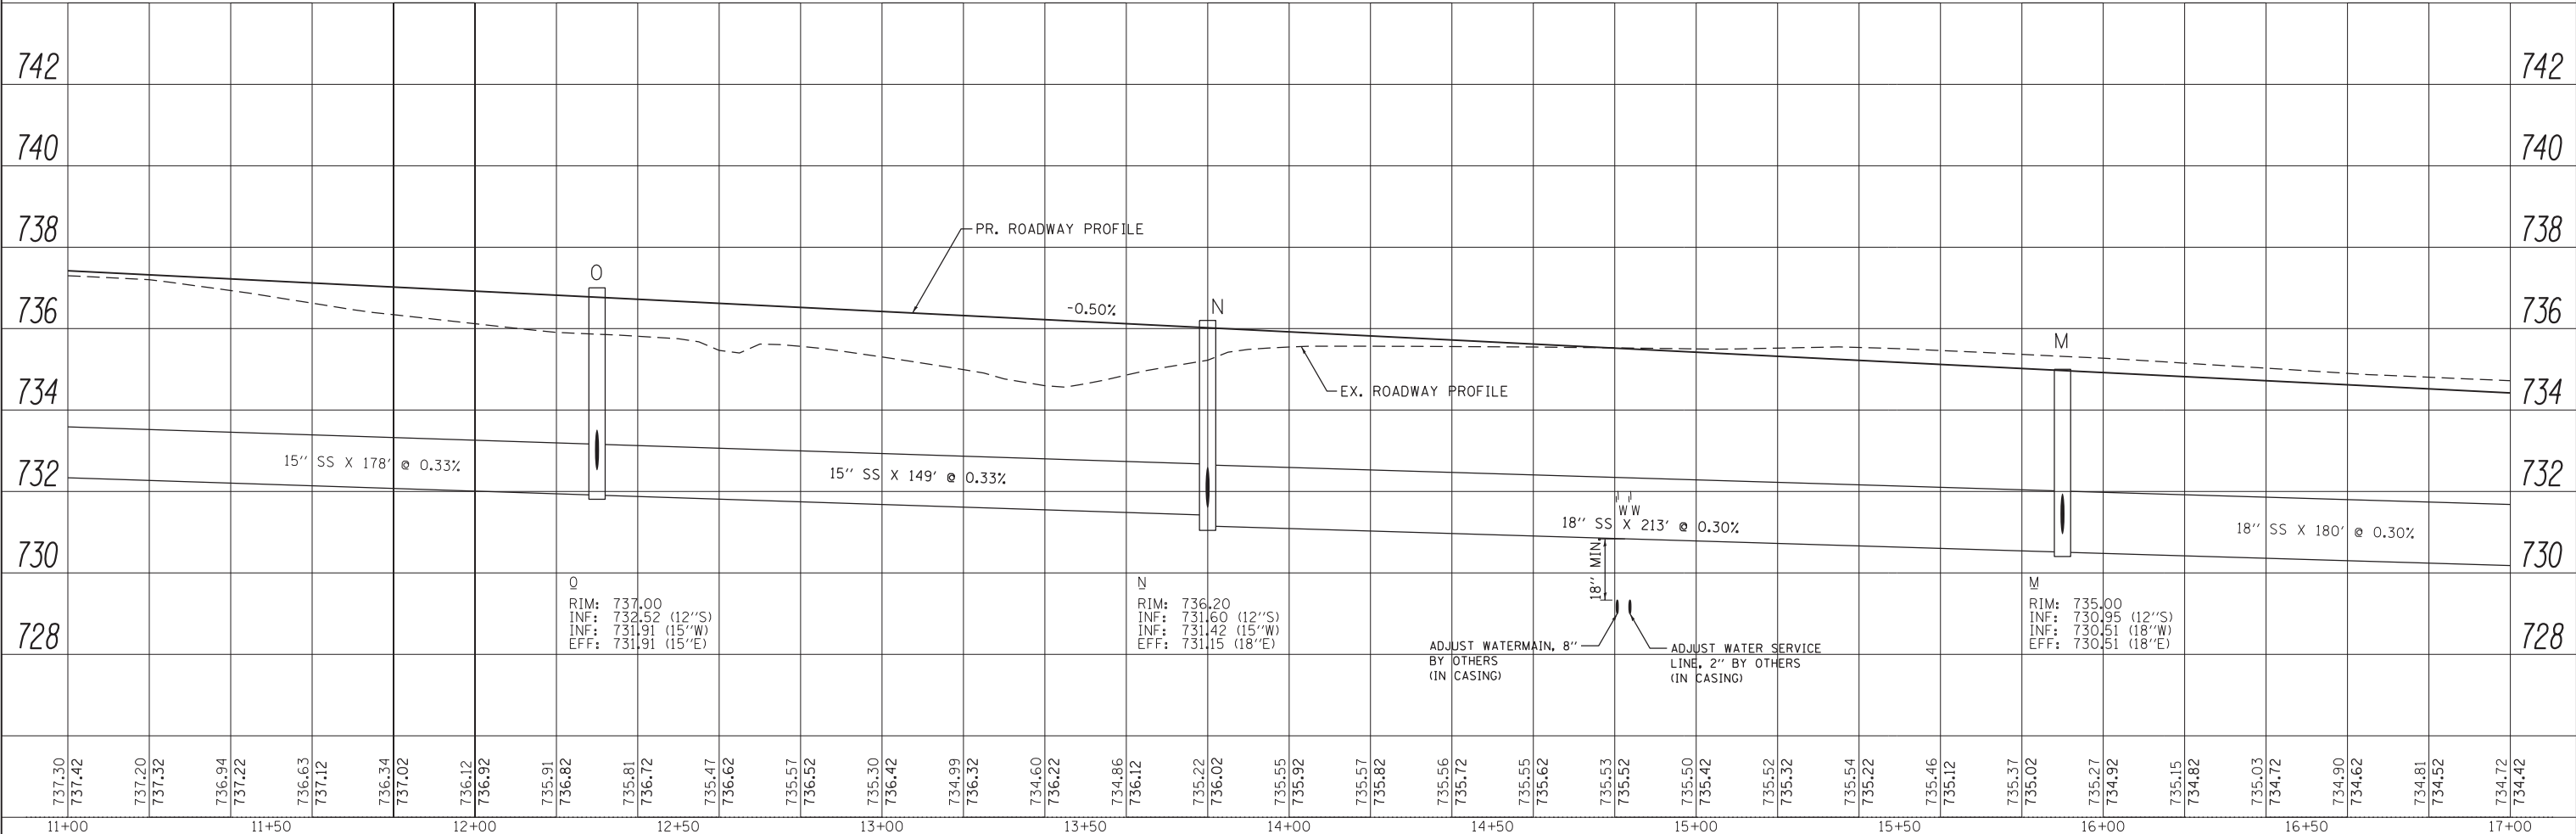

DRIVER = BPL (DRLV) \$
FILE NAME = F:\2017\14-0001-000\CAD\Profile\14-0001-00-int-PWP2.dgn

737.30	737.42	737.20	737.32	736.94	737.22	736.63	737.12	736.34	737.02	736.12	736.92	735.91	736.82	735.81	736.72	735.47	736.62	735.57	736.52	735.30	736.42	734.99	736.32	734.60	736.22	734.86	736.12	735.22	736.02	735.55	735.92	735.57	735.82	735.56	735.72	735.55	735.62	735.53	735.52	735.50	735.42	735.52	735.32	735.54	735.22	735.46	735.12	735.37	735.02	735.27	734.92	735.15	734.82	735.03	734.72	734.90	734.62	734.81	734.52	734.72	734.42
11+00	11+50	12+00	12+50	13+00	13+50	14+00	14+50	15+00	15+50	16+00	16+50	17+00																																																	

Farnsworth GROUP, INC.
2211 West Bradley Avenue
Champaign, Illinois 61821
217/352-7408, 217/352-7409 fax

USER NAME = slisenby	DESIGNED - DSC	REVISED -
PRINTER = \$SYSPRINTER_NAME\$	DRAWN - JDK	REVISED -
PLOT SCALE = 20.0000' / in.	CHECKED - JLF	REVISED -
PLOT DATE = 3/17/2017	DATE - 01/26/2017	REVISED -

**STATE OF ILLINOIS
DEPARTMENT OF TRANSPORTATION**



PLAN AND PROFILE - AIRPORT ROAD
SCALE: 1" = 20'
SHEET NO. 2 OF 8 SHEETS
STA. 11+00.00 TO STA. 17+00.00

F.A.U. RTE.	SECTION	COUNTY	TOTAL SHEETS	SHEET NO.
7190	13-00532-00-PV	CHAMPAIGN	80	20
CONTRACT NO.				
ILLINOIS FED. AID PROJECT				


DATE	
BY	
PLAN	
NO. BOOK	
NO.	
SURVEYED	
PLOTTED	
CHECKED	
AT	
FILE NAME	

DATE	
BY	
PROFILE	
NO. BOOK	
NO.	
SURVEYED	
PLOTTED	
CHECKED	
AT	
FILE NAME	

DRIVER = #PL EDVLS
 FILE NAME = F:\2017\140001-00\CAD\PLANS\140001-00-int-PWP3.dgn

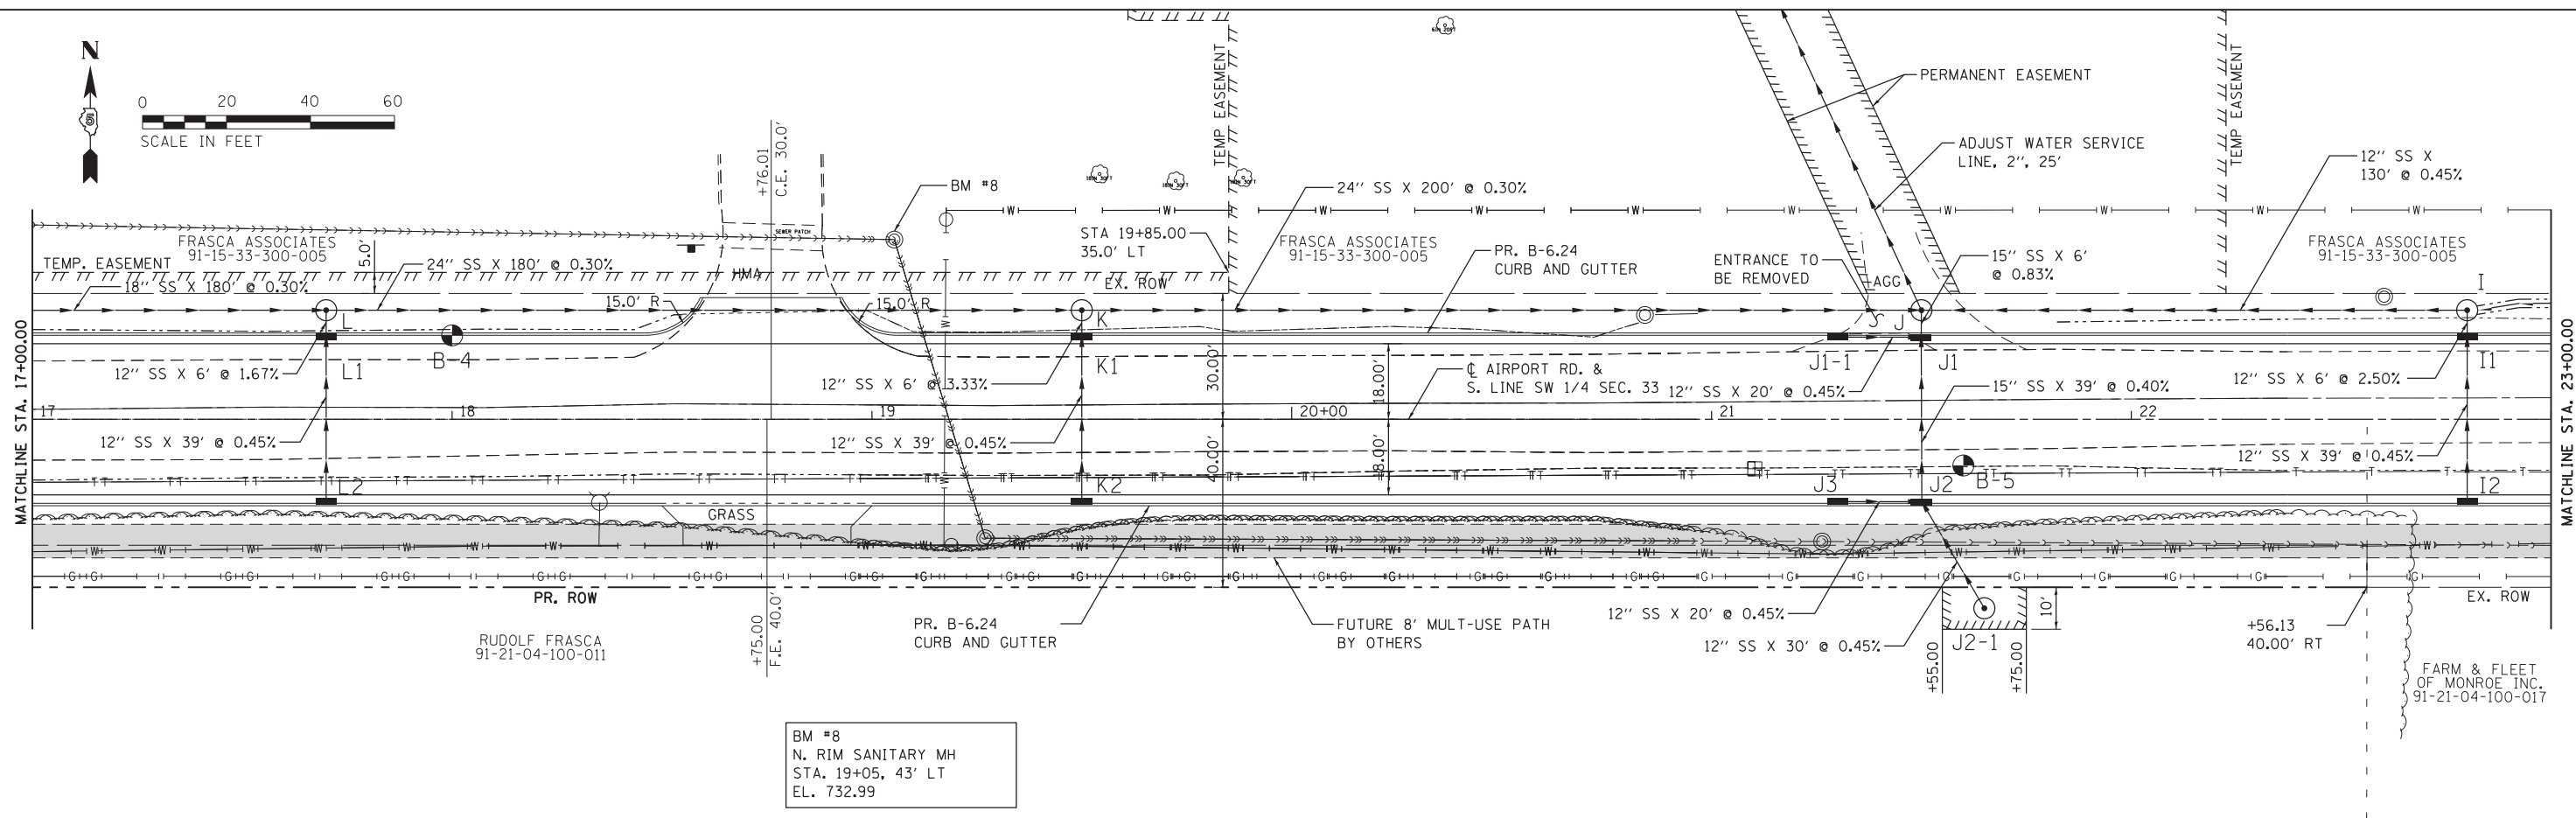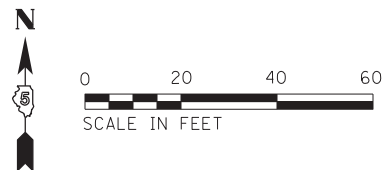

BM #8
 N. RIM SANITARY MH
 STA. 19+05, 43' LT
 EL. 732.99

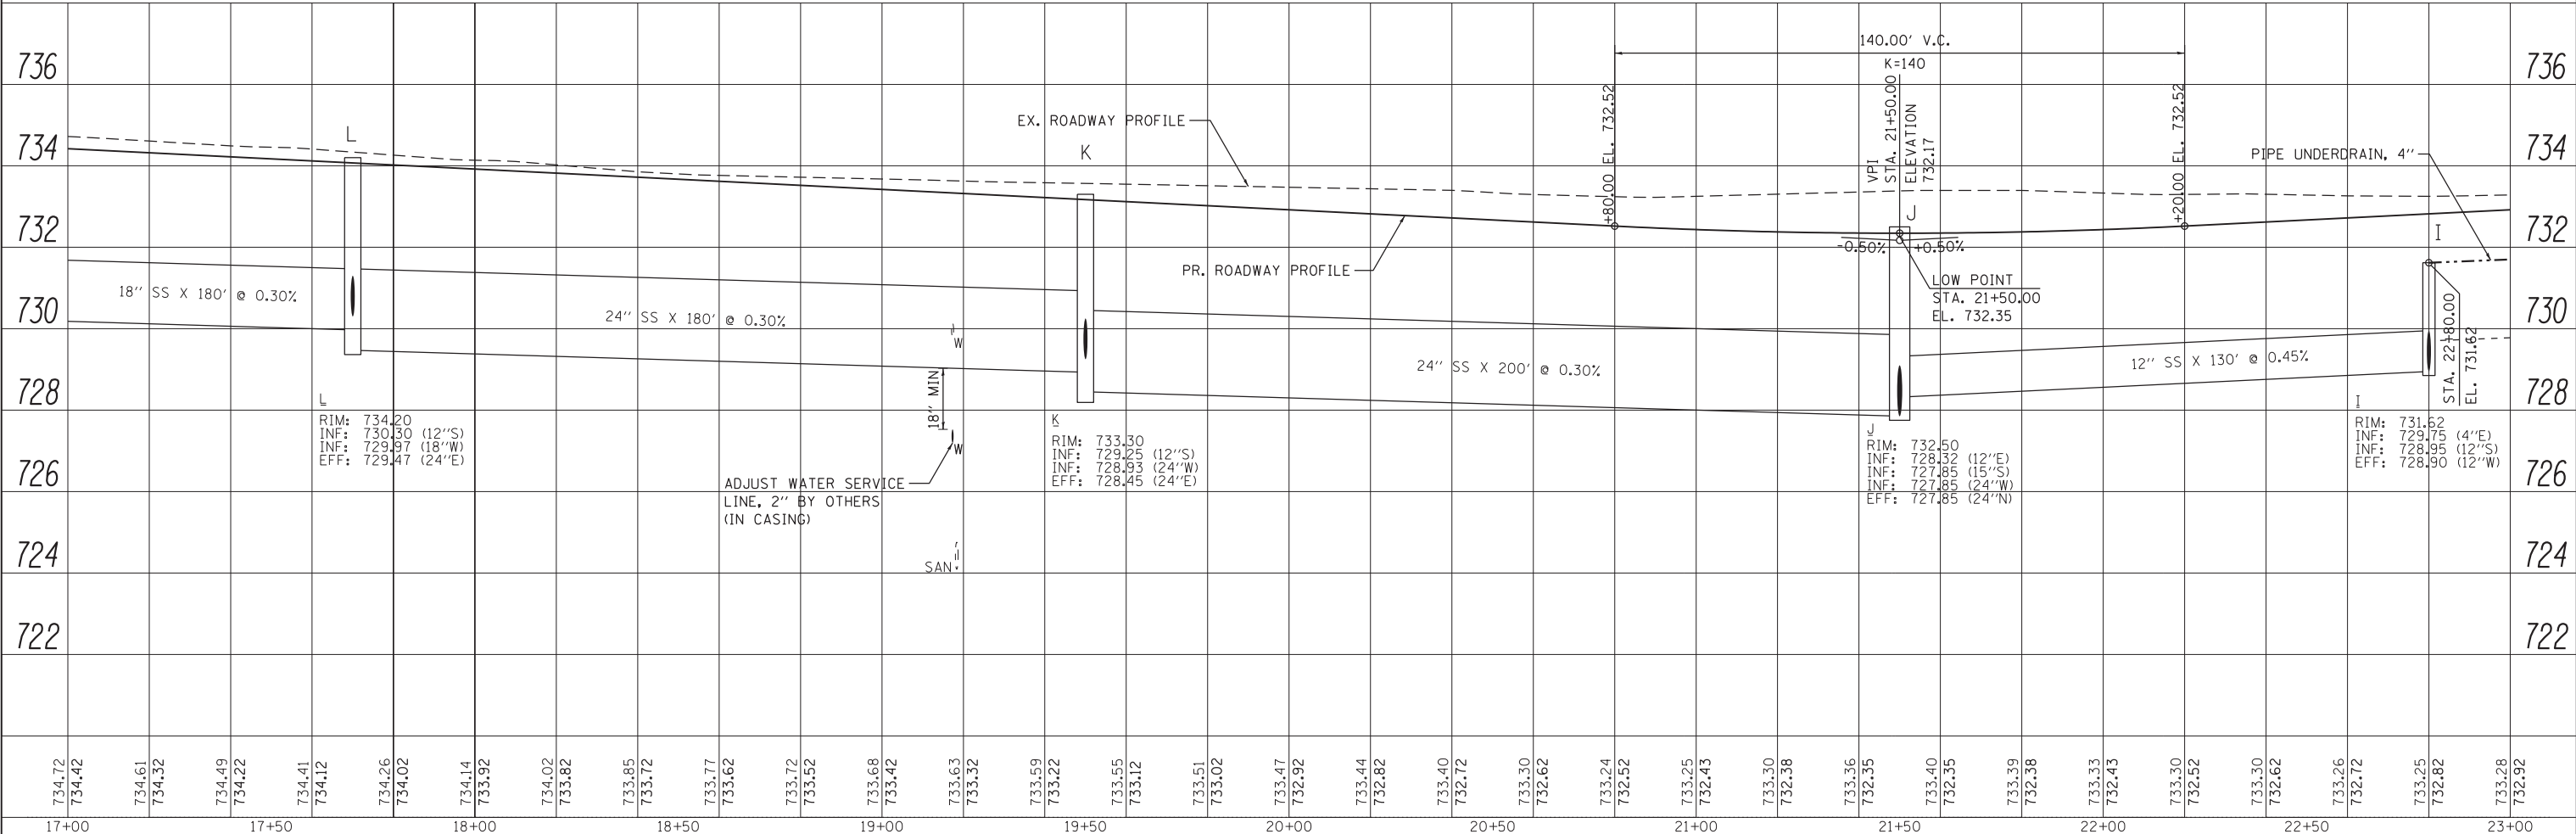

734.72	734.42	734.61	734.32	734.49	734.22	734.41	734.12	734.26	734.02	734.14	733.92	734.02	733.82	733.85	733.72	733.77	733.62	733.72	733.52	733.68	733.42	733.63	733.32	733.59	733.22	733.55	733.12	733.51	733.02	733.47	732.92	733.44	732.82	733.40	732.72	733.30	732.62	733.24	732.52	733.25	732.43	733.30	732.38	733.36	732.35	733.40	732.35	733.39	732.38	733.33	732.43	733.30	732.52	733.30	732.62	733.26	732.72	733.25	732.82	733.28	732.92
17+00	17+50	18+00	18+50	19+00	19+50	20+00	20+50	21+00	21+50	22+00	22+50	23+00																																																	


Farnsworth GROUP, INC.
 2211 West Bradley Avenue
 Champaign, Illinois 61821
 217/352-7408, 217/352-7409 fax

USER NAME = slisenby	DESIGNED - DSC	REVISED -
PRINTER = \$SYSPRINTER_NAME\$	DRAWN - JDK	REVISED -
PLOT SCALE = 20.0000' / in.	CHECKED - JLF	REVISED -
PLOT DATE = 3/17/2017	DATE - 01/26/2017	REVISED -

STATE OF ILLINOIS
DEPARTMENT OF TRANSPORTATION



PLAN AND PROFILE - AIRPORT ROAD
 SCALE: 1" = 20'
 SHEET NO. 3 OF 8 SHEETS
 STA. 17+00.00 TO STA. 23+00.00

F.A.U. RTE. 7190	SECTION 13-00532-00-PV	COUNTY CHAMPAIGN	TOTAL SHEETS 80	SHEET NO. 21
CONTRACT NO.				
ILLINOIS FED. AID PROJECT				

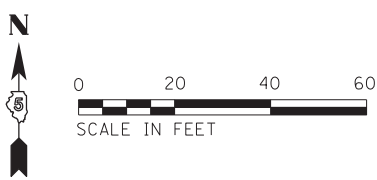

DATE	
BY	
PLAN	
NO. BOOK	
NO.	
SURVEYED	
PLOTTED	
CHECKED	
ALIGNED	
FILE NAME	

DATE	
BY	
PROFILE	
NO. BOOK	
NO.	
SURVEYED	
GRADES CHECKED	
STRUCTURE	
NOTATIS	
CHKD	

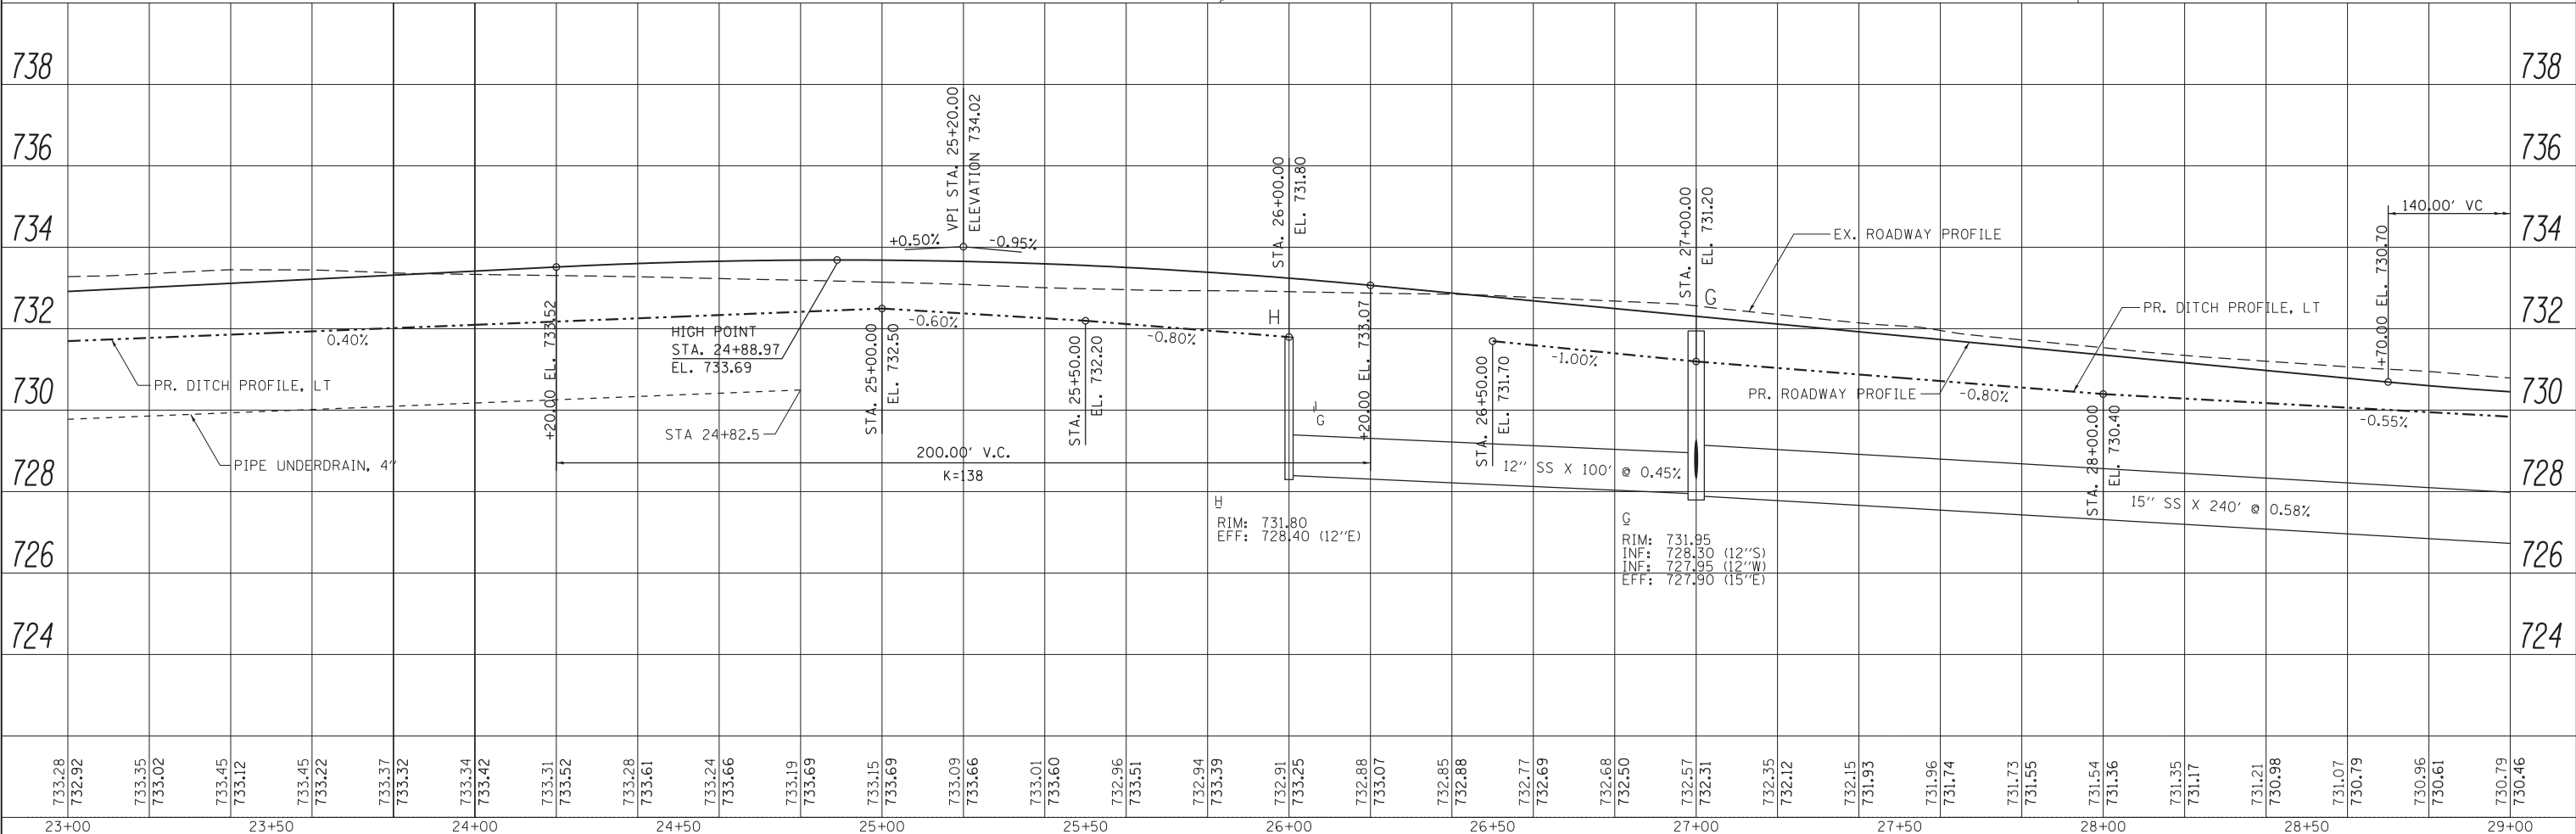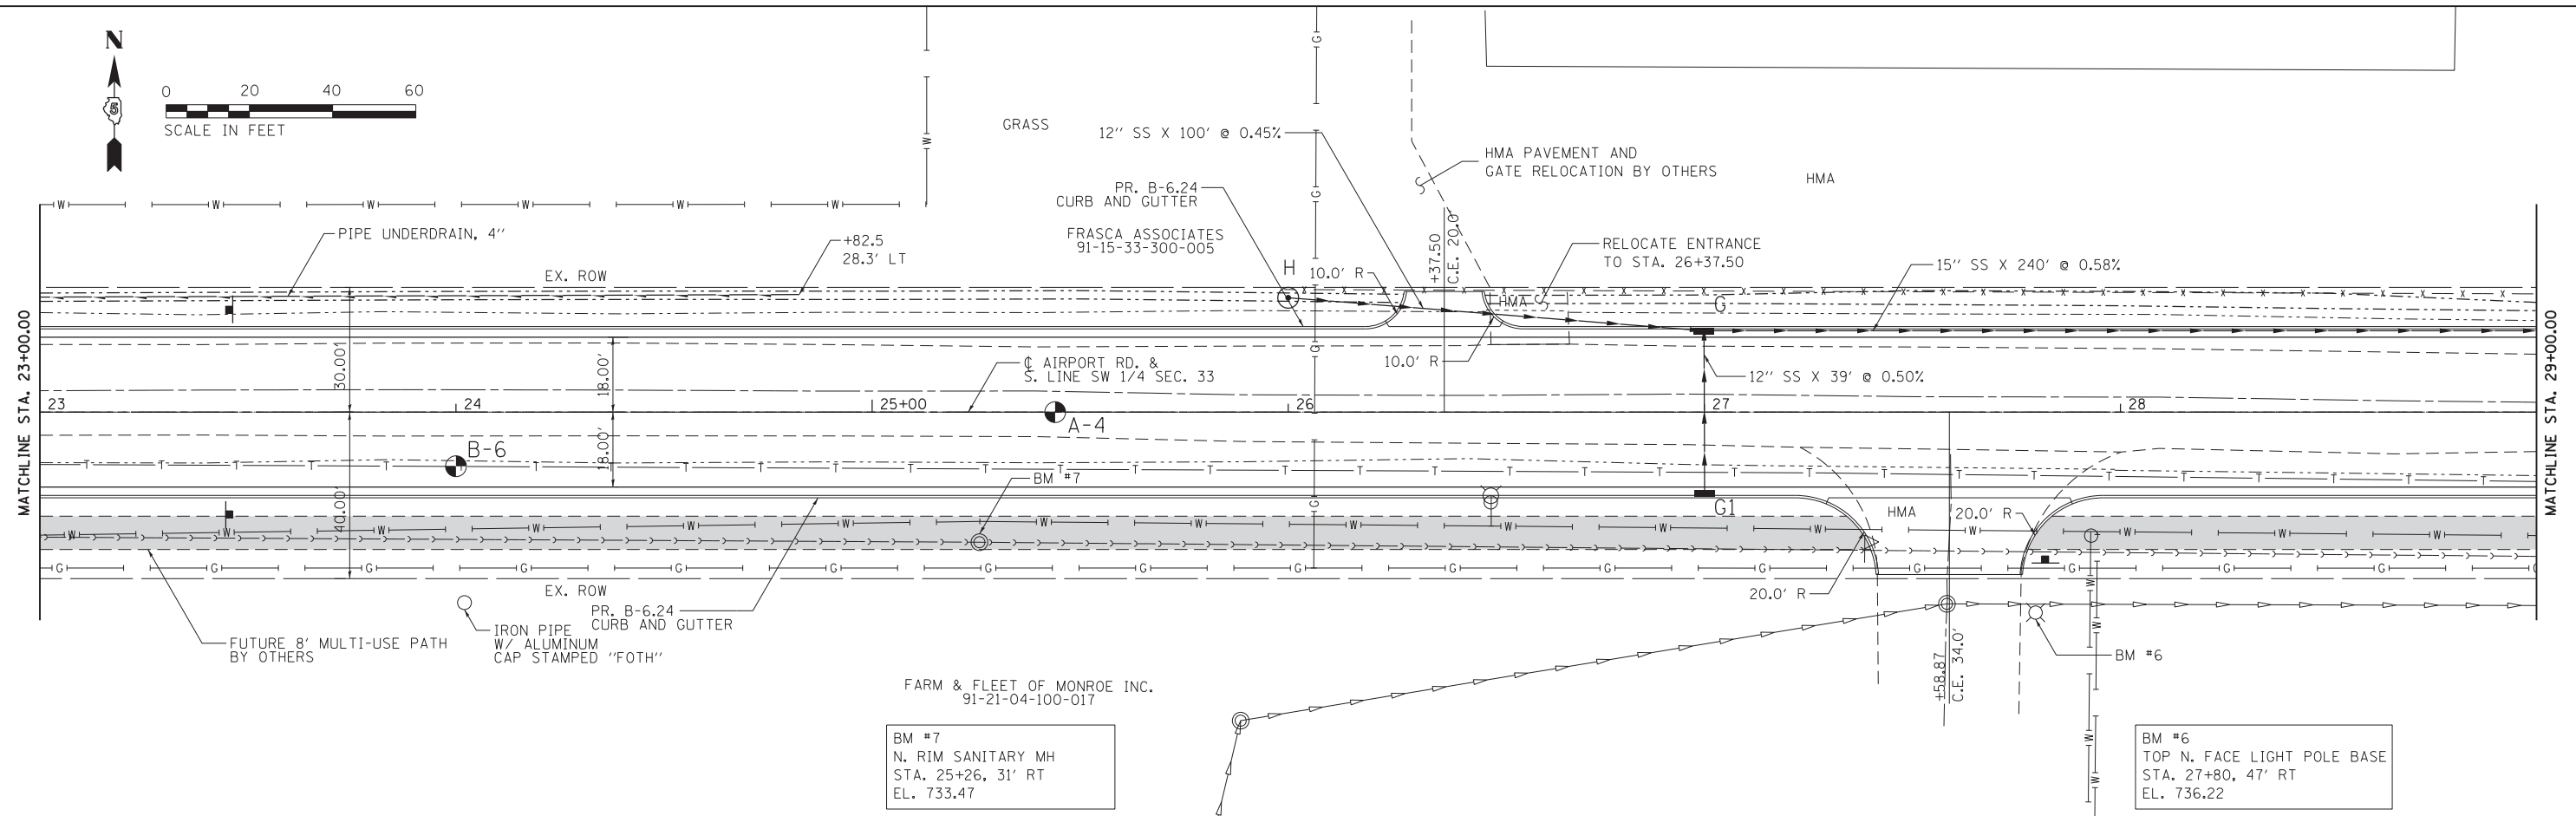

DRIVER = BPL EDVLS
 FILE NAME = F:\2017\14\0001-00\CAD\1\14\0001-00-int-PWP.dgn

733.28	733.35	733.45	733.37	733.34	733.31	733.28	733.24	733.19	733.15	733.09	733.01	732.96	732.94	732.88	732.85	732.77	732.68	732.57	732.35	732.15	731.96	731.73	731.54	731.35	731.21	731.07	730.96	730.79
23+00	23+50	24+00	24+50	25+00	25+50	26+00	26+50	27+00	27+50	28+00	28+50	29+00																

Farnsworth GROUP, INC.
 2211 West Bradley Avenue
 Champaign, Illinois 61821
 217/352-7408, 217/352-7409 fax

USER NAME = slisenby	DESIGNED - DSC	REVISED -
PRINTER = \$SYSprinter_NAME\$	DRAWN - JDK	REVISED -
PLOT SCALE = 20.0000' / in.	CHECKED - JLF	REVISED -
PLOT DATE = 3/17/2017	DATE - 01/26/2017	REVISED -



STATE OF ILLINOIS
DEPARTMENT OF TRANSPORTATION

PLAN AND PROFILE - AIRPORT ROAD
 SCALE: 1" = 20'
 SHEET NO. 4 OF 8 SHEETS
 STA. 23+00.00 TO STA. 29+00.00

F.A.U. RTE.	SECTION	COUNTY	TOTAL SHEETS	SHEET NO.
7190	13-00532-00-PV	CHAMPAIGN	80	22
CONTRACT NO.				
ILLINOIS FED. AID PROJECT				

DATE	
BY	
PLAN	SURVEYED
	NOTED
	CHECKED
	ALIGNED
	AS BUILT
	FILE NAME
	NO.

DATE	
BY	
PROFILE	SURVEYED
	NOTED
	CHECKED
	GRADES
	STRUCTURE
	NOTATIONS
	CHKD
	NO.

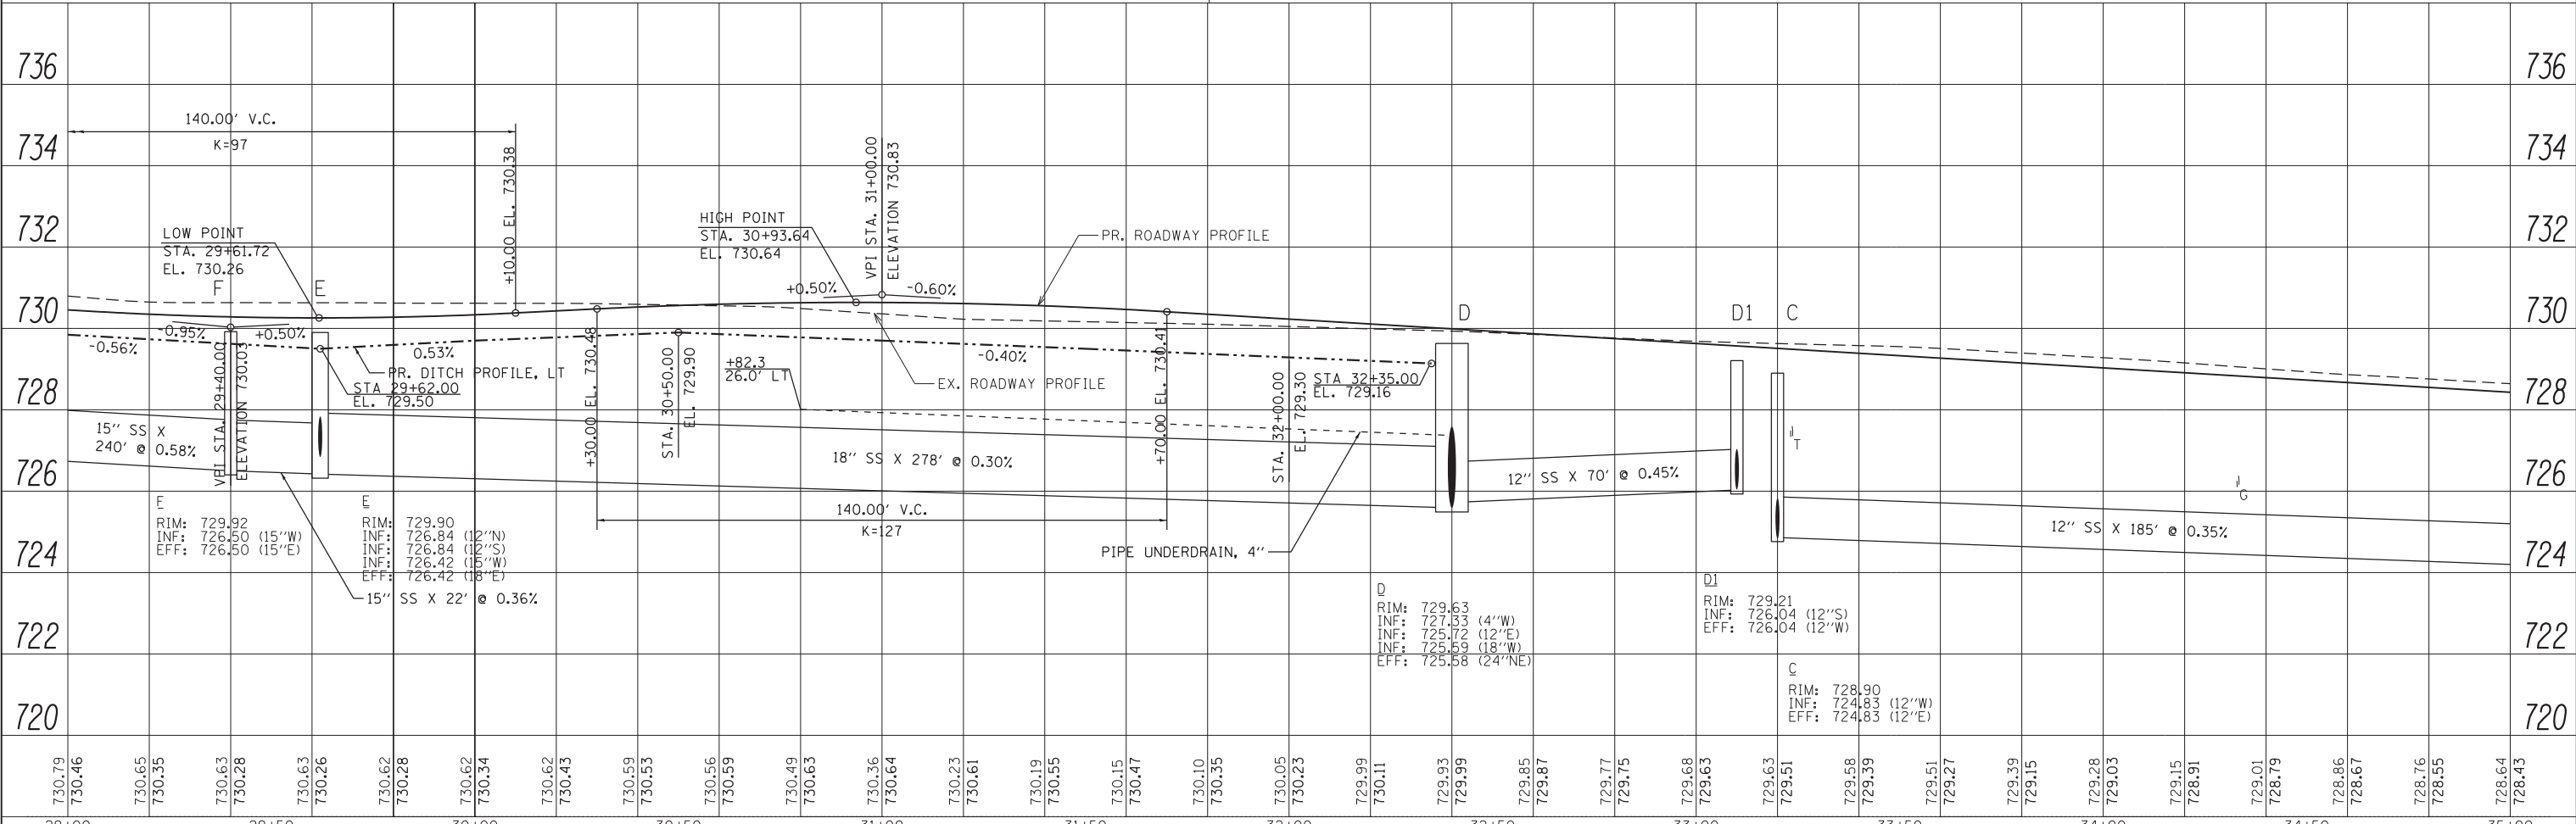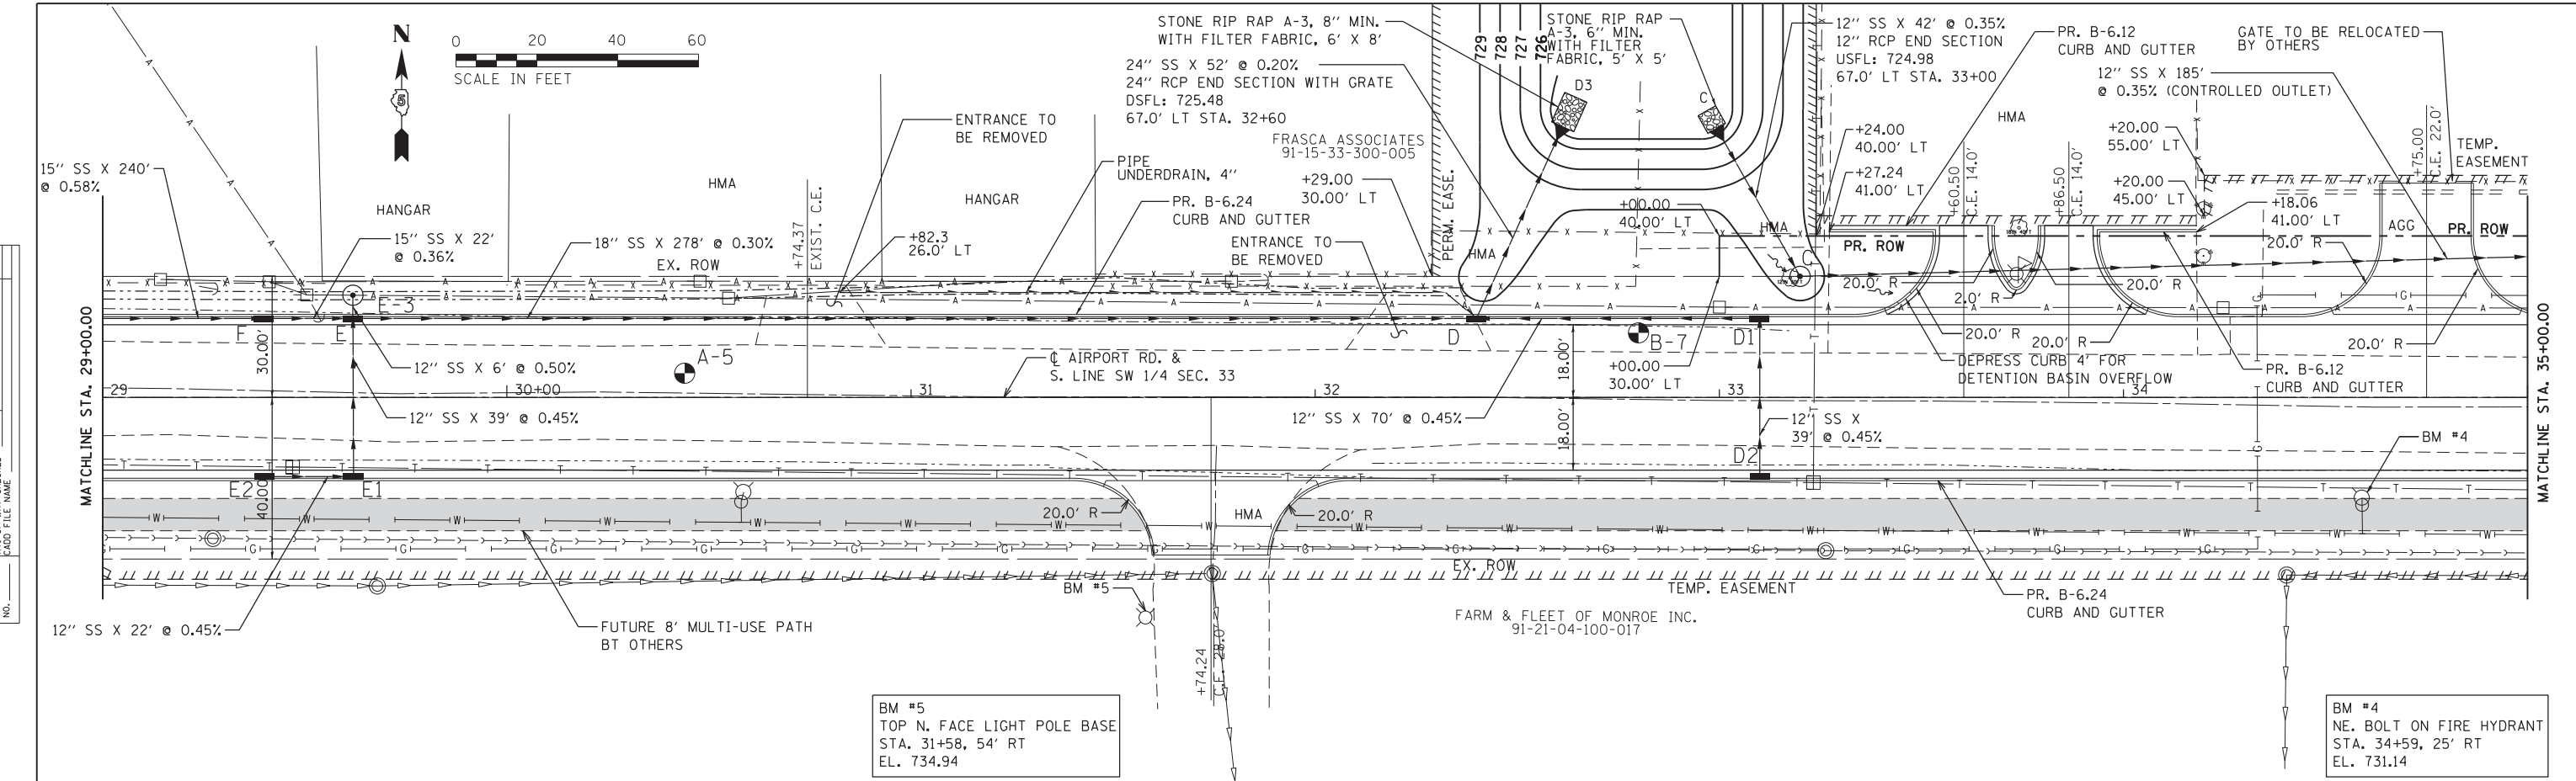

DRIVER = P:\PL\DRVL\$
 FILE NAME = P:\2017\140001-00\CAD\PLANS\140001-00-int-PWP5.dgn

Farnsworth
 GROUP, INC.
 2211 West Bradley Avenue
 Champaign, Illinois 61821
 217/352-7408, 217/352-7409 fax

USER NAME = slsbnby
 PRINTER = \$SYSPRINTER_NAME\$
 PLOT SCALE = 20.0000' / in.
 PLOT DATE = 3/17/2017

DESIGNED -	DSC	REVISED -	
DRAWN -	JDK	REVISED -	
CHECKED -	JLF	REVISED -	
DATE -	01/26/2017	REVISED -	

STATE OF ILLINOIS
DEPARTMENT OF TRANSPORTATION



PLAN AND PROFILE - AIRPORT ROAD

SCALE: 1" = 20' SHEET NO. 5 OF 8 SHEETS STA. 29+00.00 TO STA. 35+00.00

F.A.U. RTE.	SECTION	COUNTY	TOTAL SHEETS	SHEET NO.
7190	13-00532-00-PV	CHAMPAIGN	80	23
CONTRACT NO.				
ILLINOIS FED. AID PROJECT				

DATE	
BY	
PLAN	SURVEYED
	PLOTTED
	CHECKED
	ALLOTTED
	FILE NAME
	NO.

DATE	
BY	
PROFILE	SURVEYED
	PLOTTED
	CHECKED
	ALLOTTED
	FILE NAME
	NO.

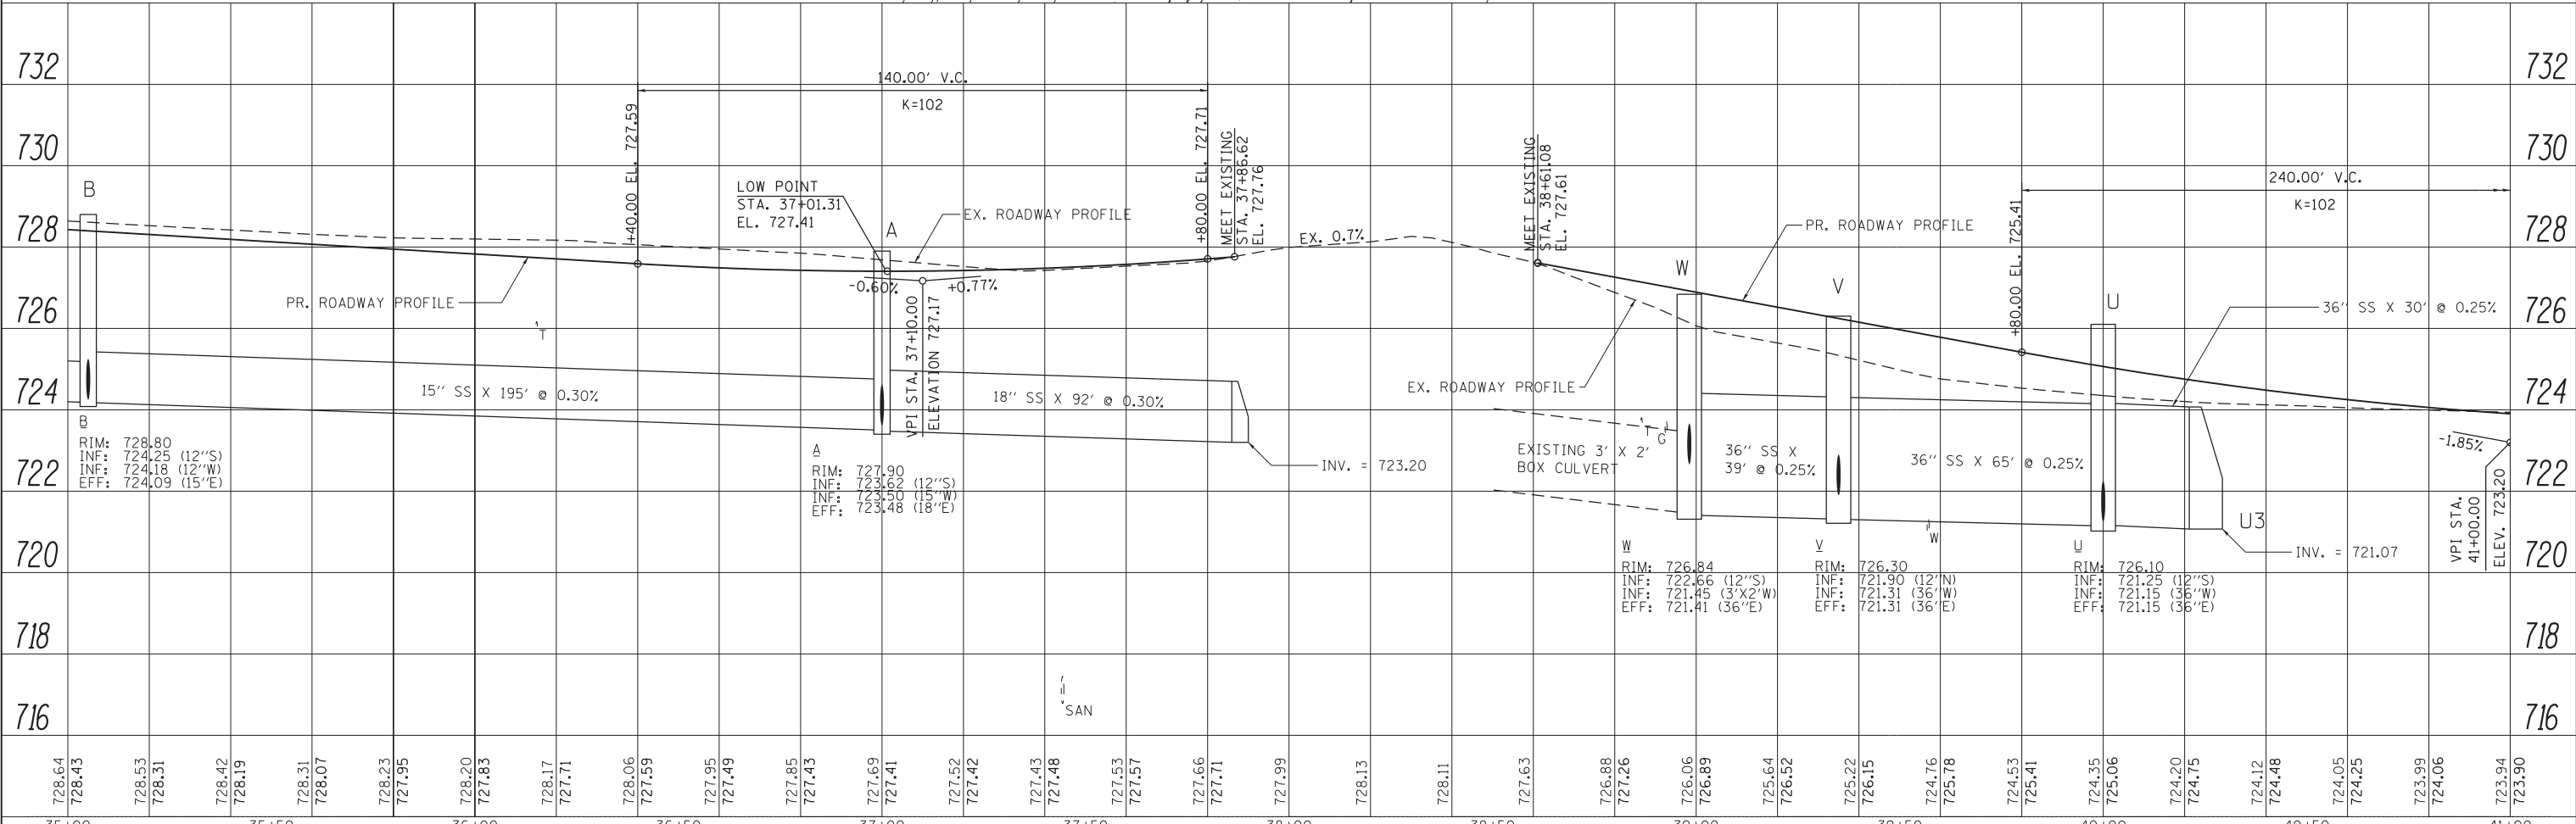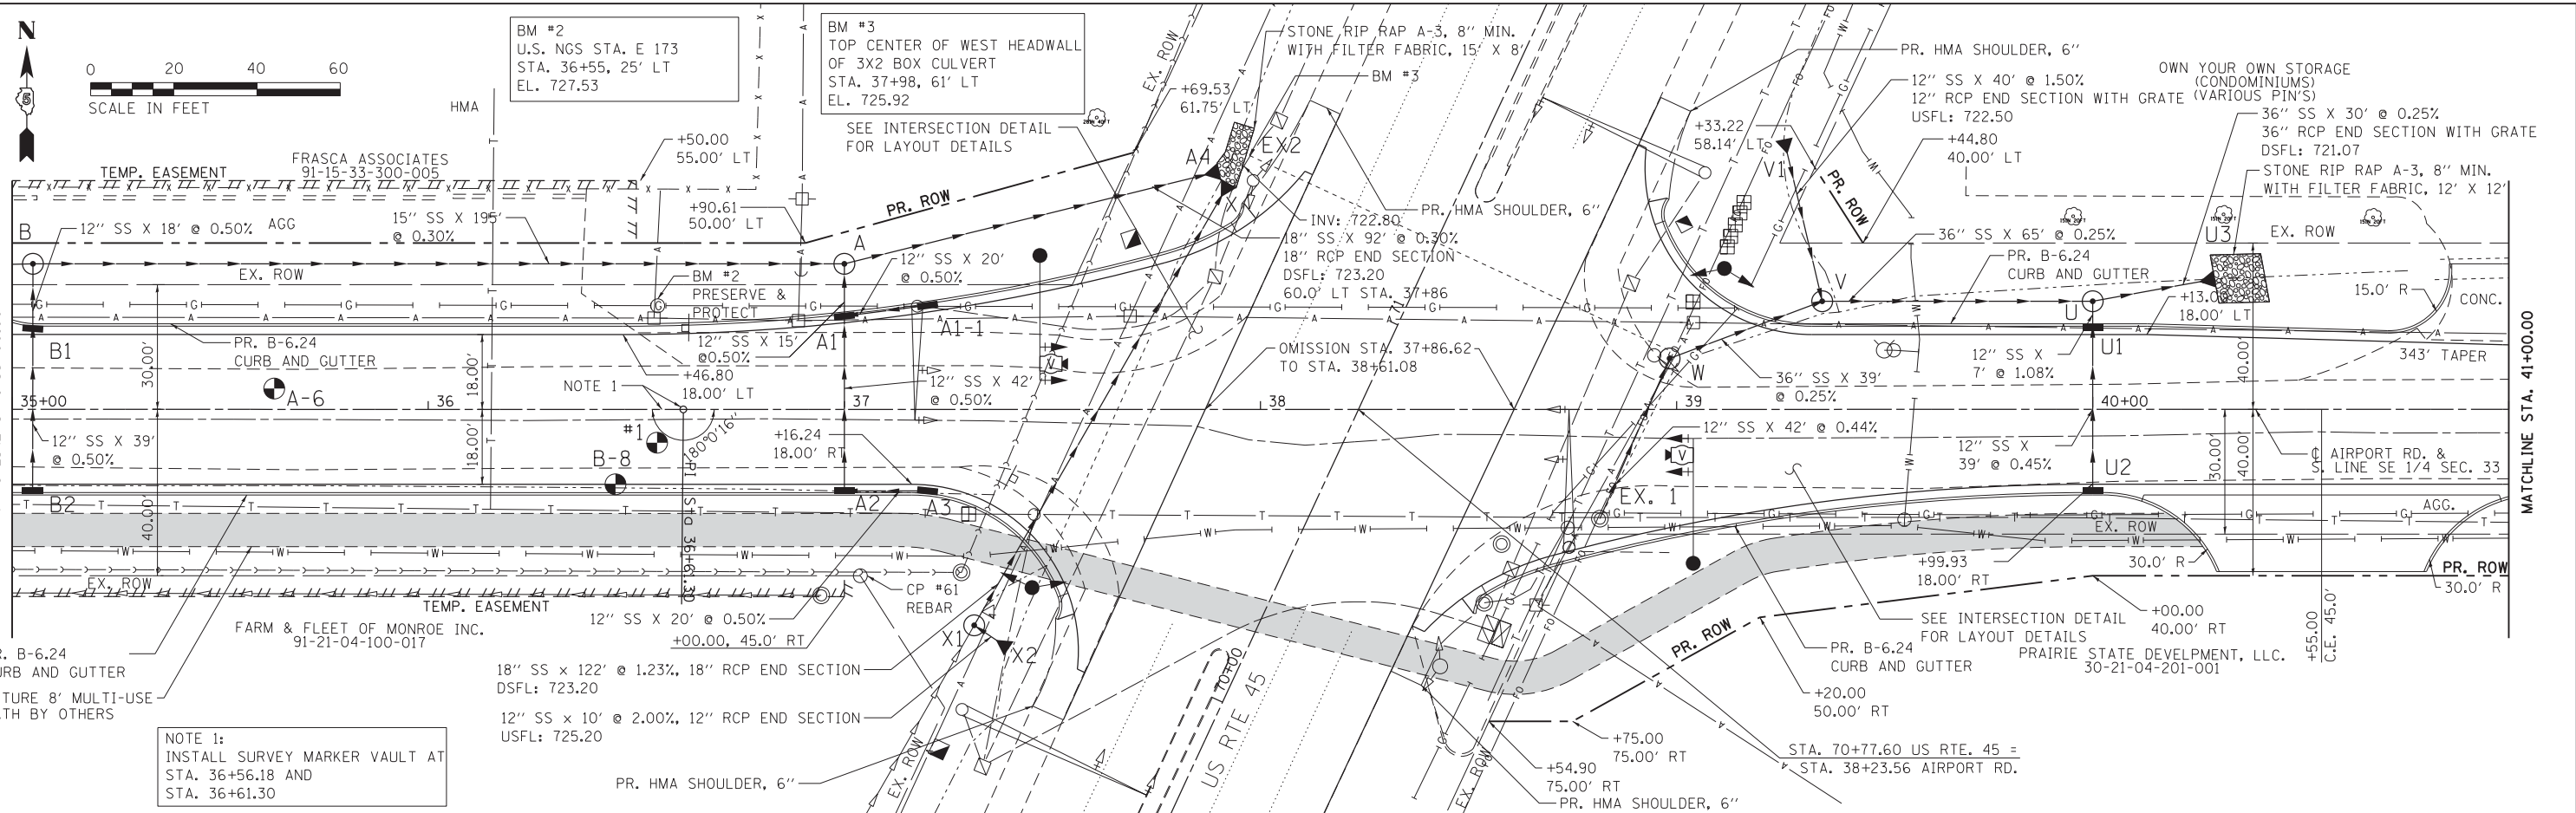

DRIVER = BPL (DVL) \$
 FILE NAME = F:\2017\11\0001\000\CAD\PLANS\140001-00-int-PWP.dgn


Farnsworth
 GROUP, INC.
 2211 West Bradley Avenue
 Champaign, Illinois 61821
 217/352-7408, 217/352-7409 fax

USER NAME = slisenby	DESIGNED - DSC	REVISED -
PRINTER = \$SYSPRINTER_NAME\$	DRAWN - JDJ	REVISED -
PLOT SCALE = 20.0000' / in.	CHECKED - JLF	REVISED -
PLOT DATE = 3/17/2017	DATE - 01/26/2017	REVISED -

STATE OF ILLINOIS
DEPARTMENT OF TRANSPORTATION



PLAN AND PROFILE - AIRPORT ROAD
 SCALE: 1" = 20'
 SHEET NO. 6 OF 8 SHEETS
 STA. 35+00.00 TO STA. 41+00.00

F.A.U. RTE.	SECTION	COUNTY	TOTAL SHEETS	SHEET NO.
7190	13-00532-00-PV	CHAMPAIGN	80	24
CONTRACT NO.				
ILLINOIS FED. AID PROJECT				

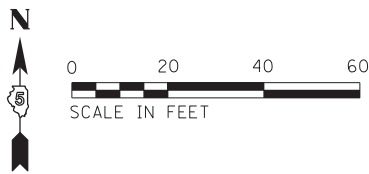

PLAN	SURVEYED	BY	DATE
	PLOTTED		
	CHECKED		
	ALIGNED		
	FILED		
	NO. _____		

PROFILE	SURVEYED	BY	DATE
	PLOTTED		
	CHECKED		
	GRADES		
	STRUCTURE		
	NOTATIONS		
	CHKD		
	NO. _____		

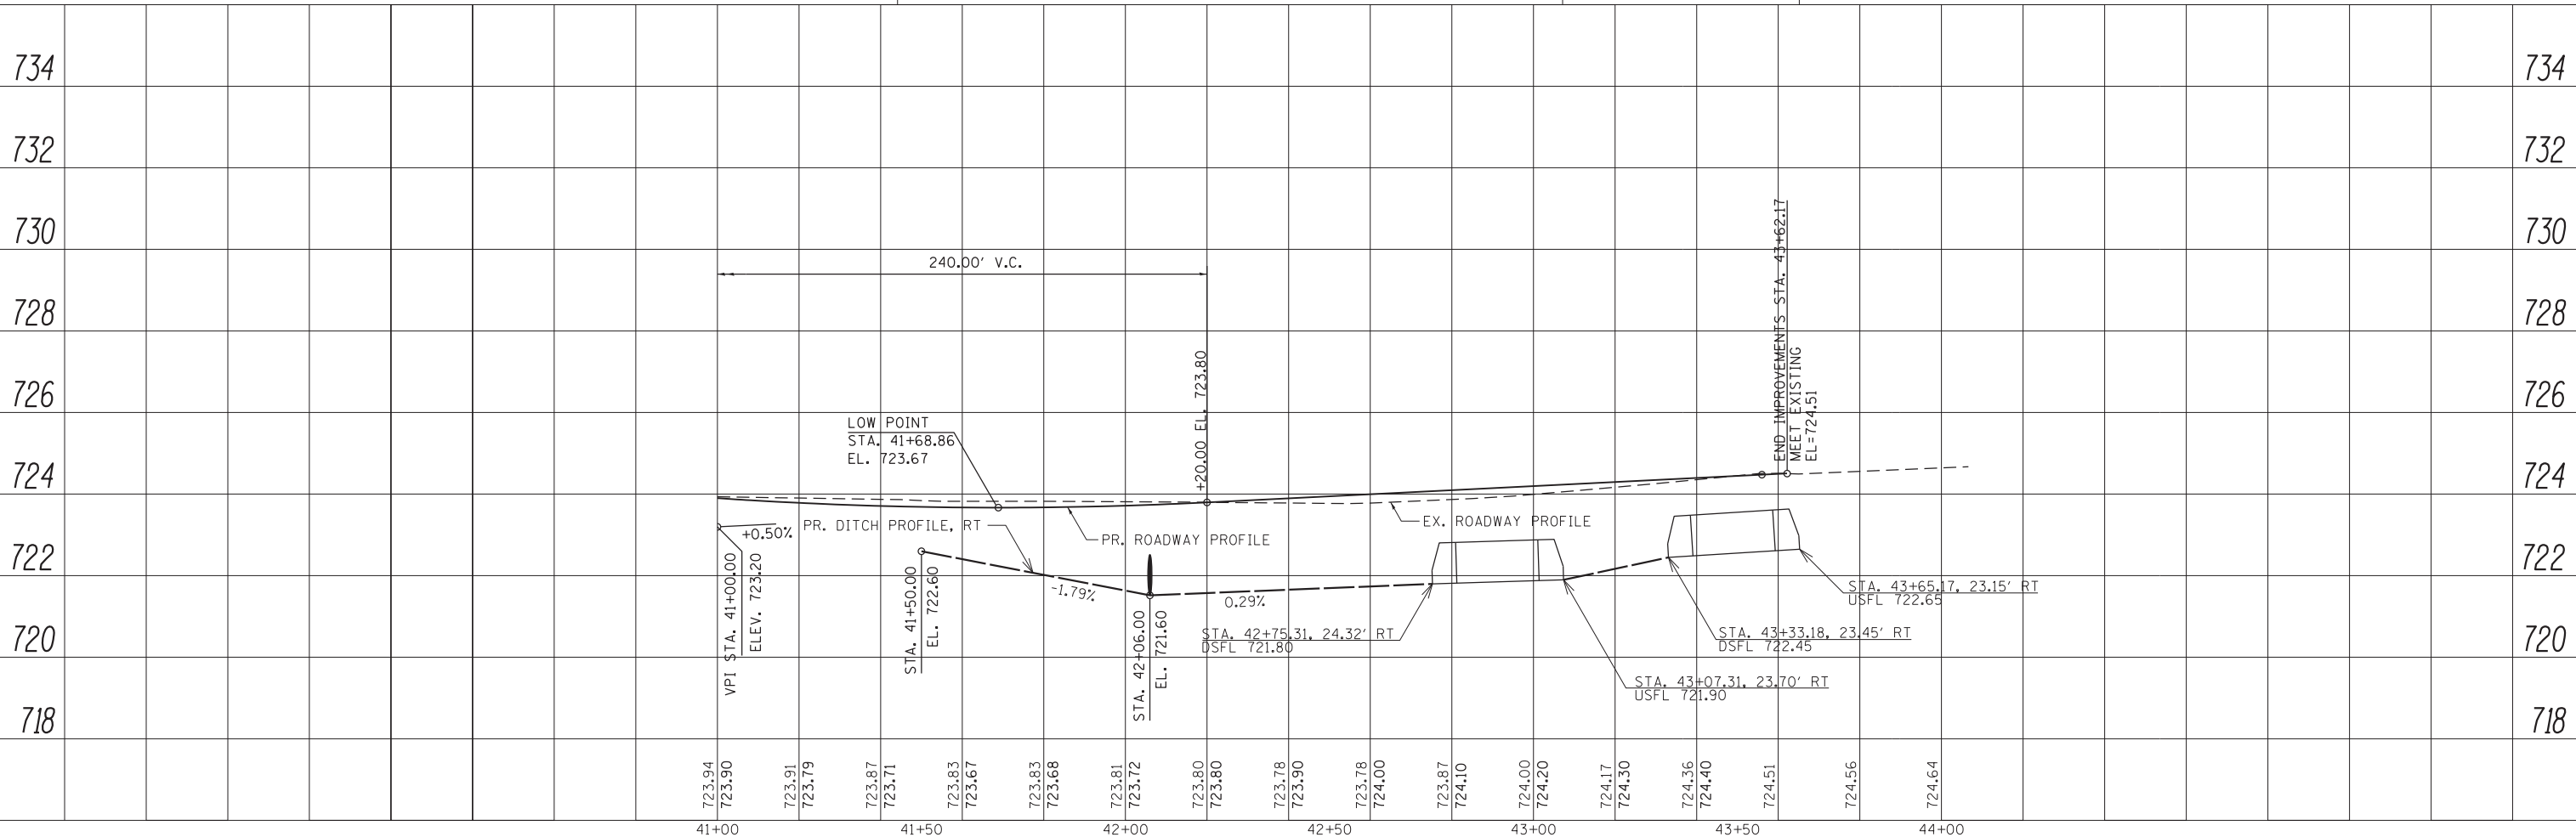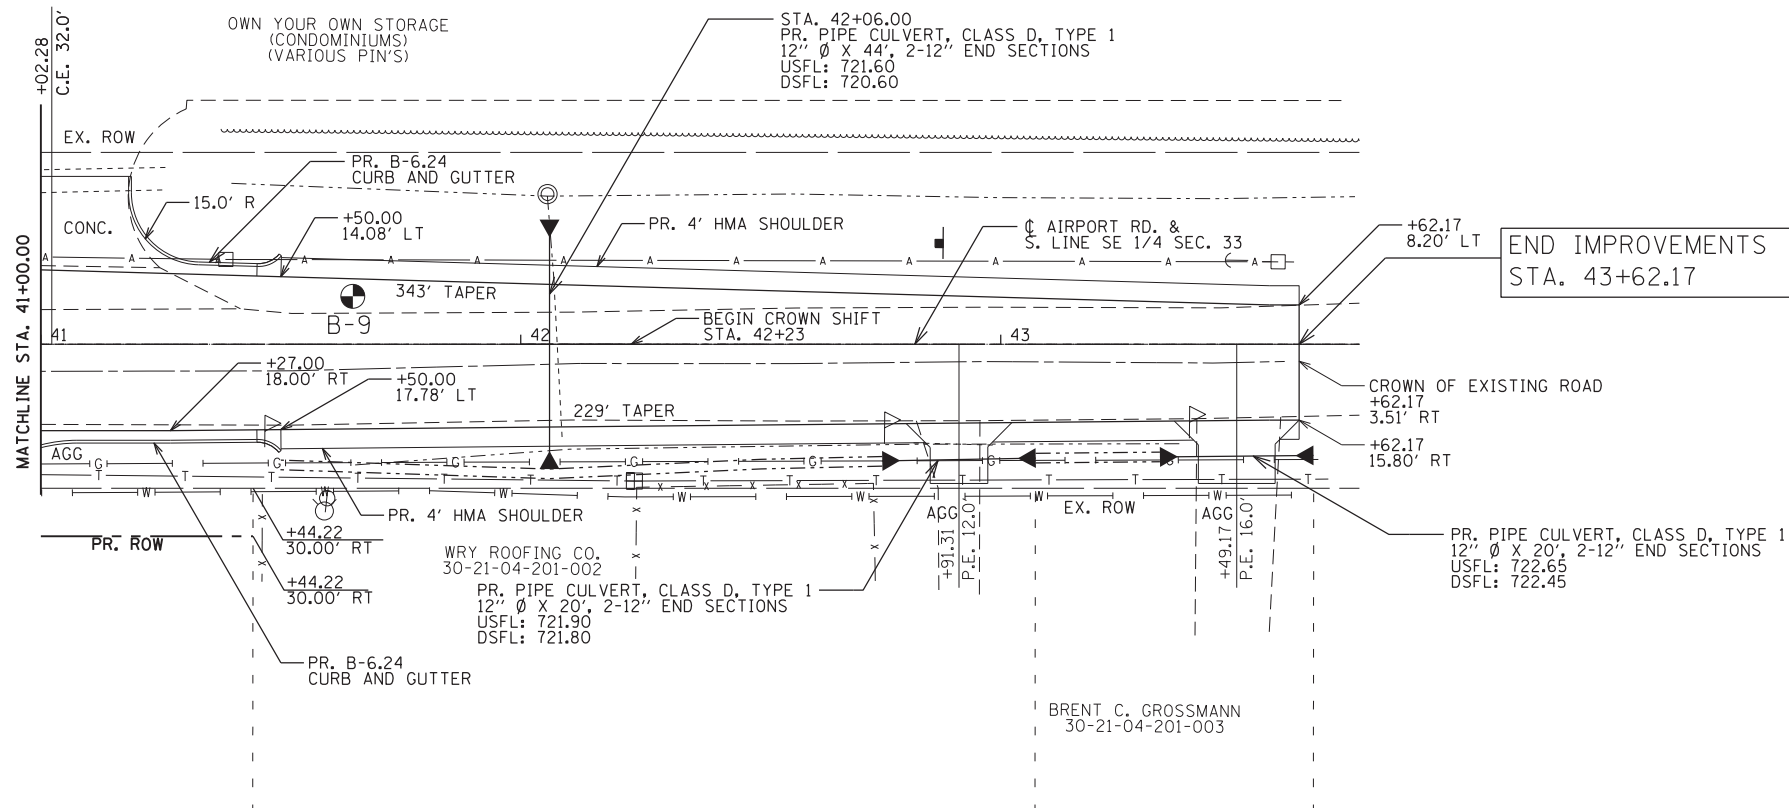

DRIVER = BPL DORVLS
 FILE NAME = F:\2014\14001-00\CAD\PLANS\14001-00-int-PN7.dgn


Farnsworth
 GROUP, INC.
 2211 West Bradley Avenue
 Champaign, Illinois 61821
 217/352-7408, 217/352-7409 fax

USER NAME = slisenby	DESIGNED - DSC	REVISED -
PRINTER = \$SYSPRINTER_NAME\$	DRAWN - JDK	REVISED -
PLOT SCALE = 20.0000' / in.	CHECKED - JLF	REVISED -
PLOT DATE = 3/17/2017	DATE - 01/26/2017	REVISED -

STATE OF ILLINOIS
DEPARTMENT OF TRANSPORTATION

PLAN AND PROFILE - AIRPORT ROAD
 SCALE: 1" = 20'
 SHEET NO. 7 OF 8 SHEETS
 STA. 41+00.00 TO STA. 43+62.17



F.A.U. RTE.	SECTION	COUNTY	TOTAL SHEETS	SHEET NO.
7190	13-00532-00-PV	CHAMPAIGN	80	25
CONTRACT NO.				
ILLINOIS FED. AID PROJECT				

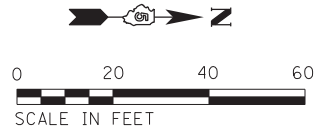

PLAN	SURVEYED	BY	DATE
	PLOTTED		
	CHECKED		
	ALIGNED		
	FILED		
NOTE BOOK NO.	CADD FILE NAME		

PROFILE	SURVEYED	BY	DATE
	PLOTTED		
	CHECKED		
	GRADES		
	STRUCTURE		
NOTE BOOK NO.	NOTATIS CHFD		

DRIVER = P:\DWL \$
 FILE NAME = F:\2014\14001-00\CAD\PLAN\14001-00-int-PWP.dgn

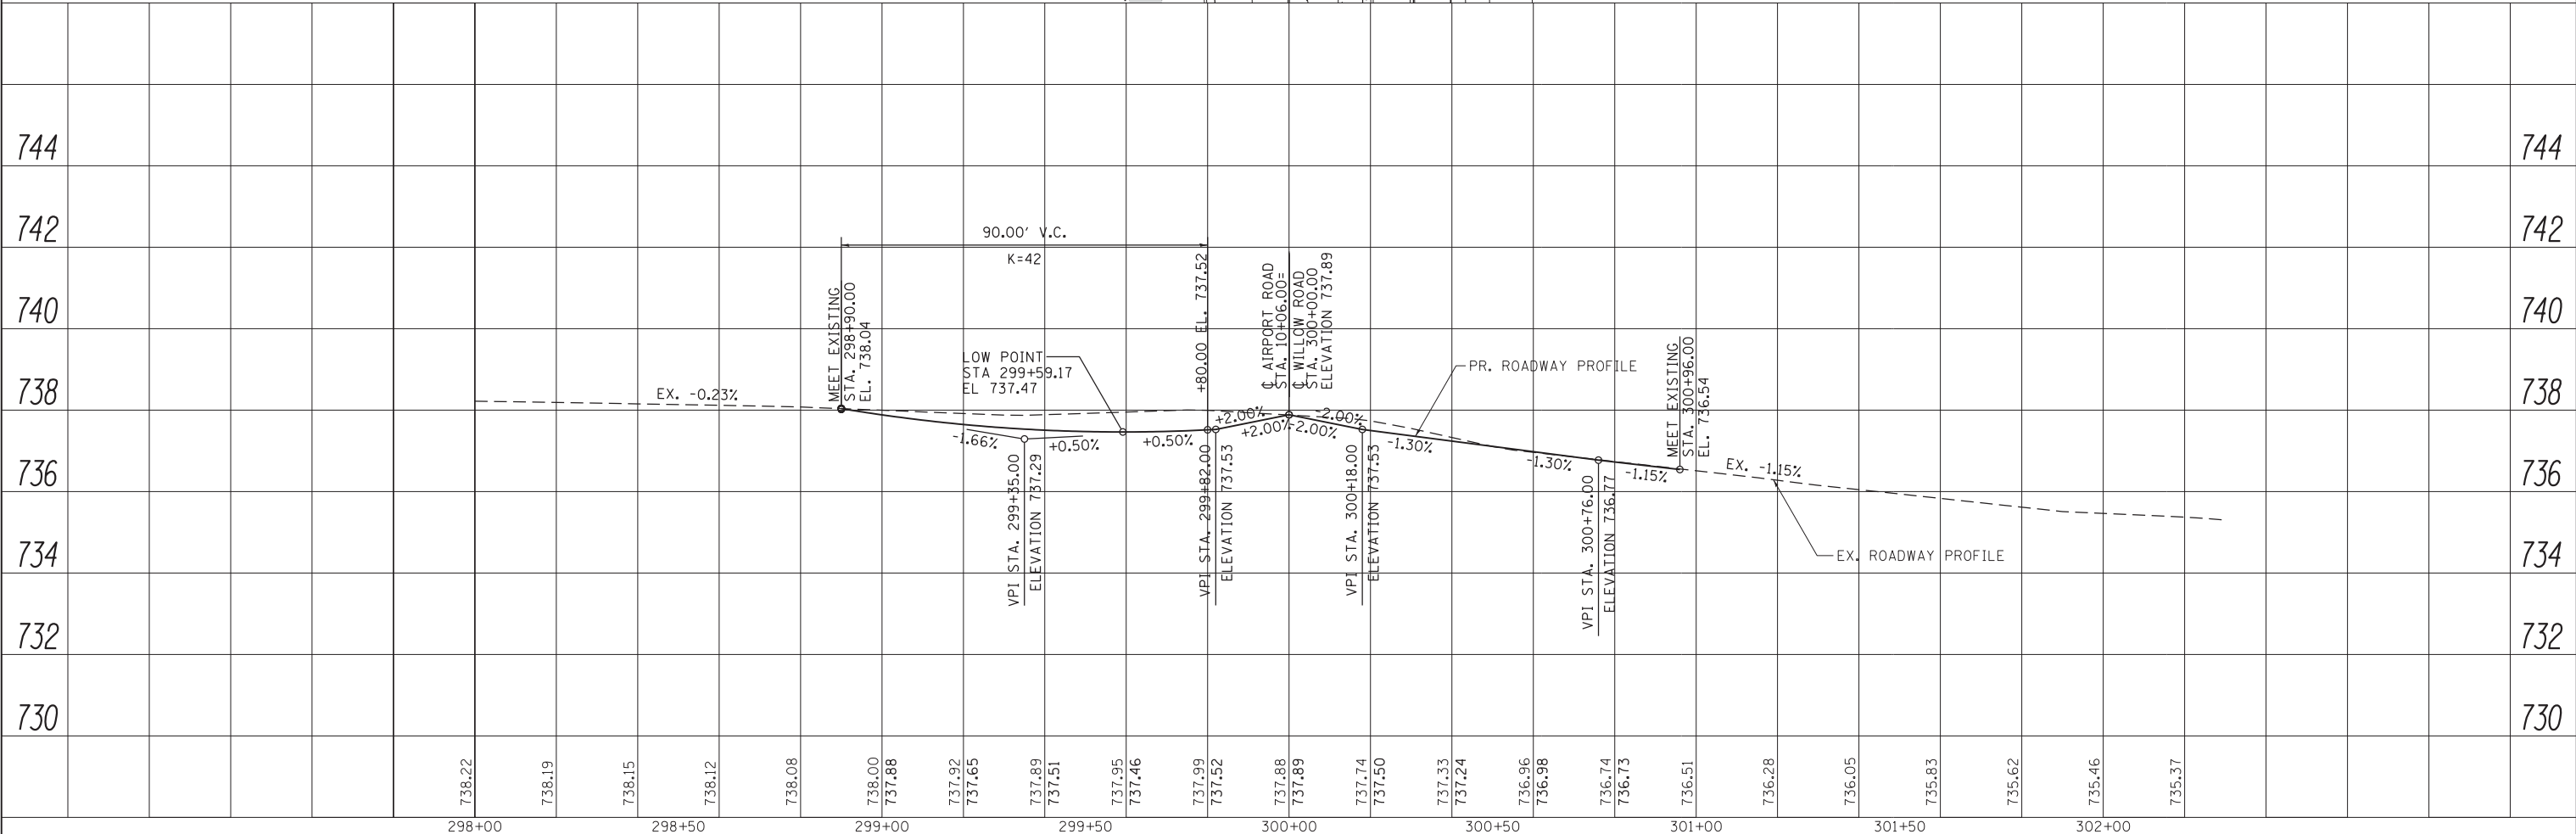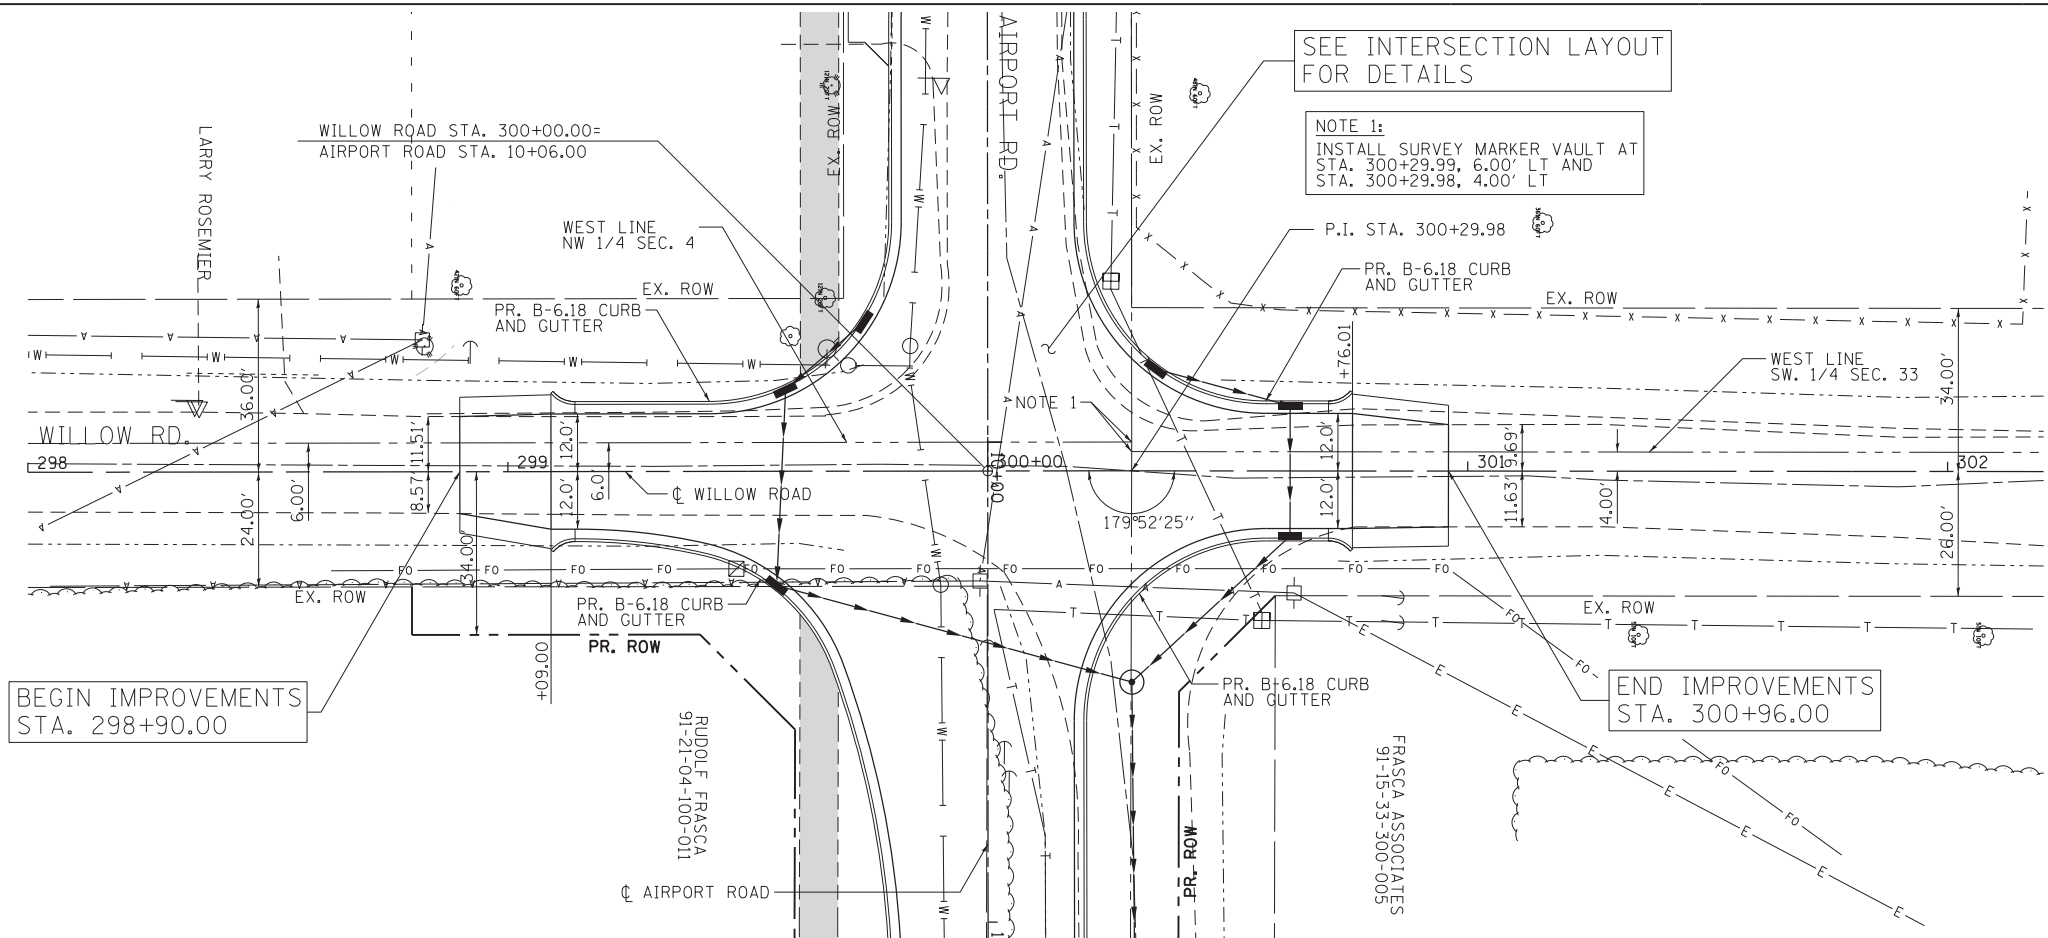

738.22	738.19	738.15	738.12	738.08	738.00	737.88	737.92	737.65	737.89	737.51	737.95	737.46	737.99	737.52	737.88	737.89	737.74	737.50	737.33	737.24	736.96	736.98	736.74	736.73	736.51	736.28	736.05	735.83	735.62	735.46	735.37		
298+00	298+50	299+00	299+50	300+00	300+50	301+00	301+50	302+00																									

Farnsworth GROUP, INC.
 2211 West Bradley Avenue
 Champaign, Illinois 61821
 217/352-7408, 217/352-7409 fax

USER NAME = slisenby	DESIGNED - DSC	REVISED -
PRINTER = \$SYSPRINTER_NAME\$	DRAWN - JDK	REVISED -
PLOT SCALE = 20.0000' / in.	CHECKED - JLF	REVISED -
PLOT DATE = 3/17/2017	DATE - 01/26/2017	REVISED -

**STATE OF ILLINOIS
 DEPARTMENT OF TRANSPORTATION**

PLAN AND PROFILE - WILLOW ROAD
 SCALE: 1" = 20'
 SHEET NO. 8 OF 8 SHEETS
 STA. 298+90.00 TO STA. 300+96.00

F.A.U. RTE.	SECTION	COUNTY	TOTAL SHEETS	SHEET NO.
7190	13-00532-00-PV	CHAMPAIGN	80	26
CONTRACT NO.				
ILLINOIS FED. AID PROJECT				