



DATE	
BY	
SURVEYED	
PLANNED	
NOTED	
FILE NAME	



© Copyright Hanson Professional Services Inc. 2014

DATE	
BY	
SURVEYED	
PLANNED	
NOTED	
FILE NAME	

DATE	4/29/14
BY	RSJ
SURVEYED	
PLANNED	
NOTED	
FILE NAME	

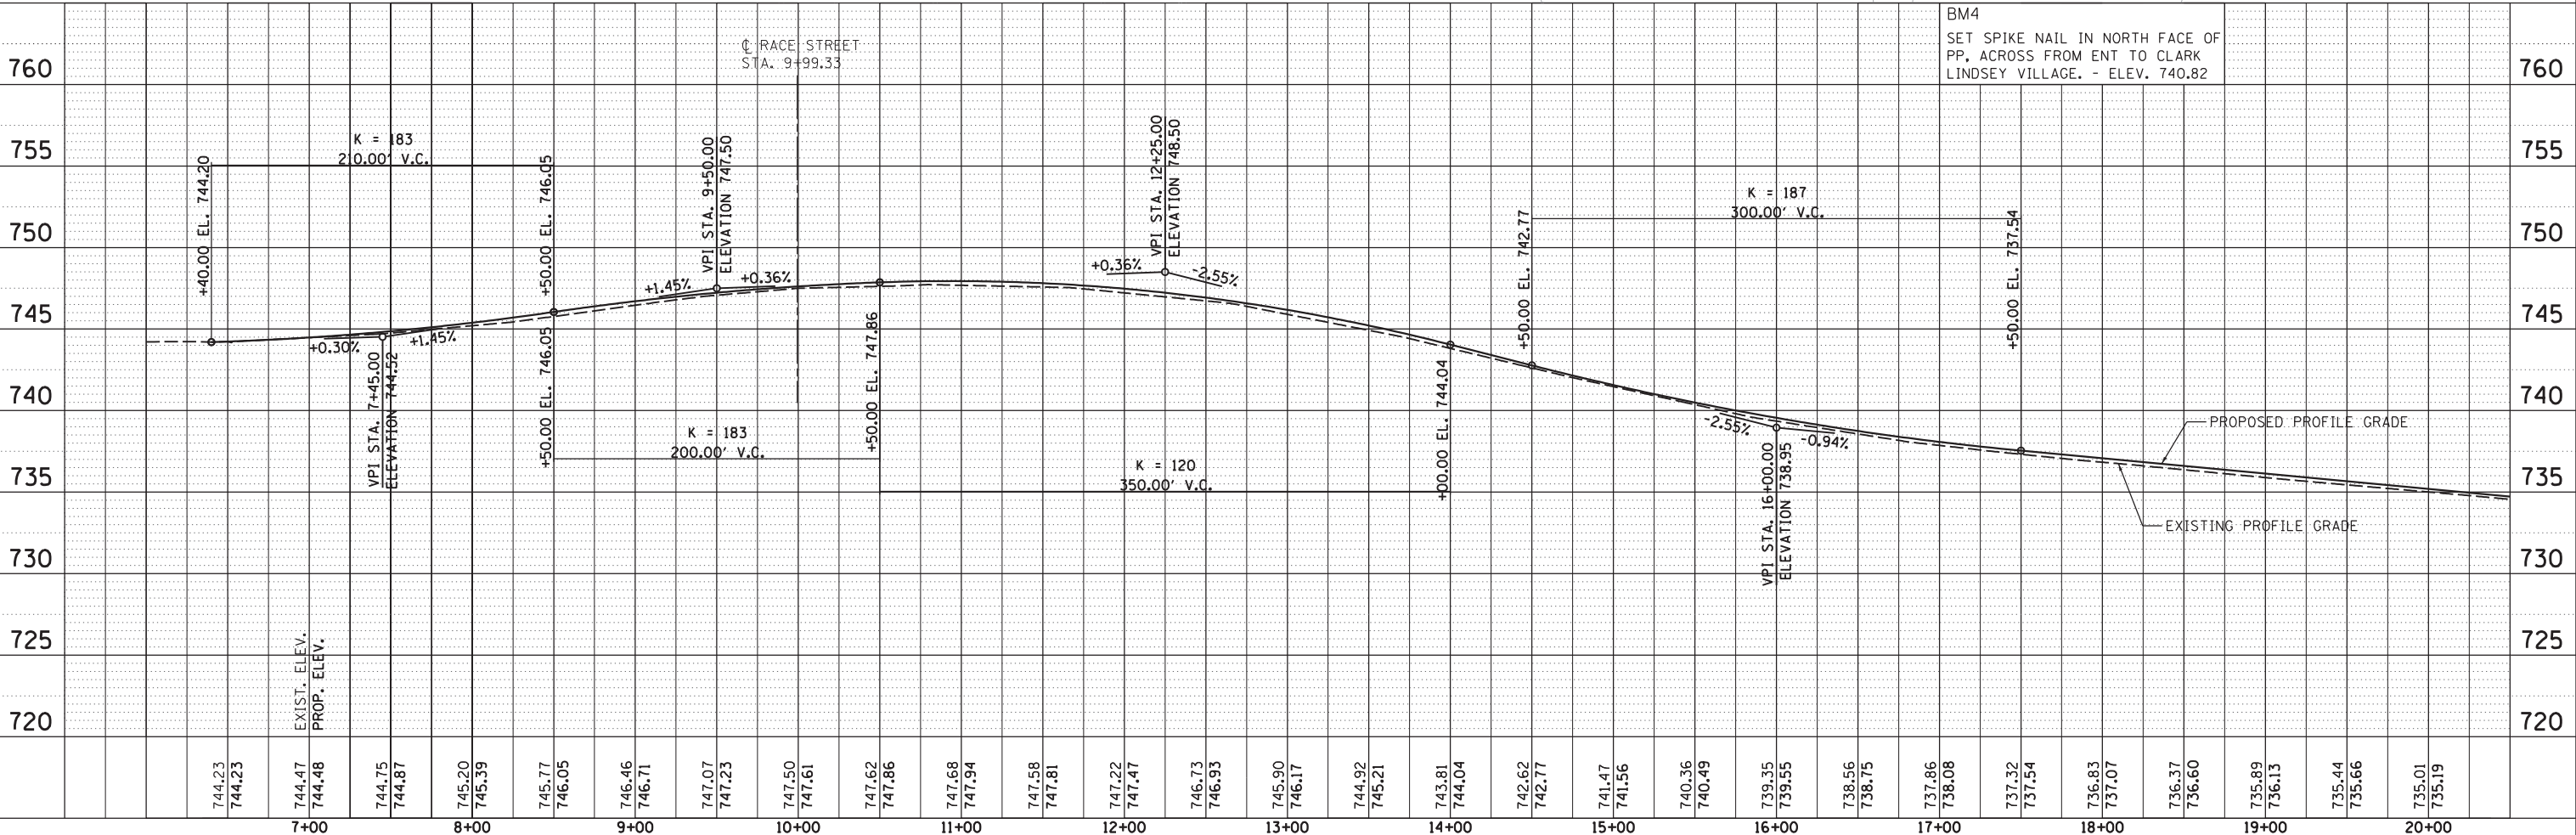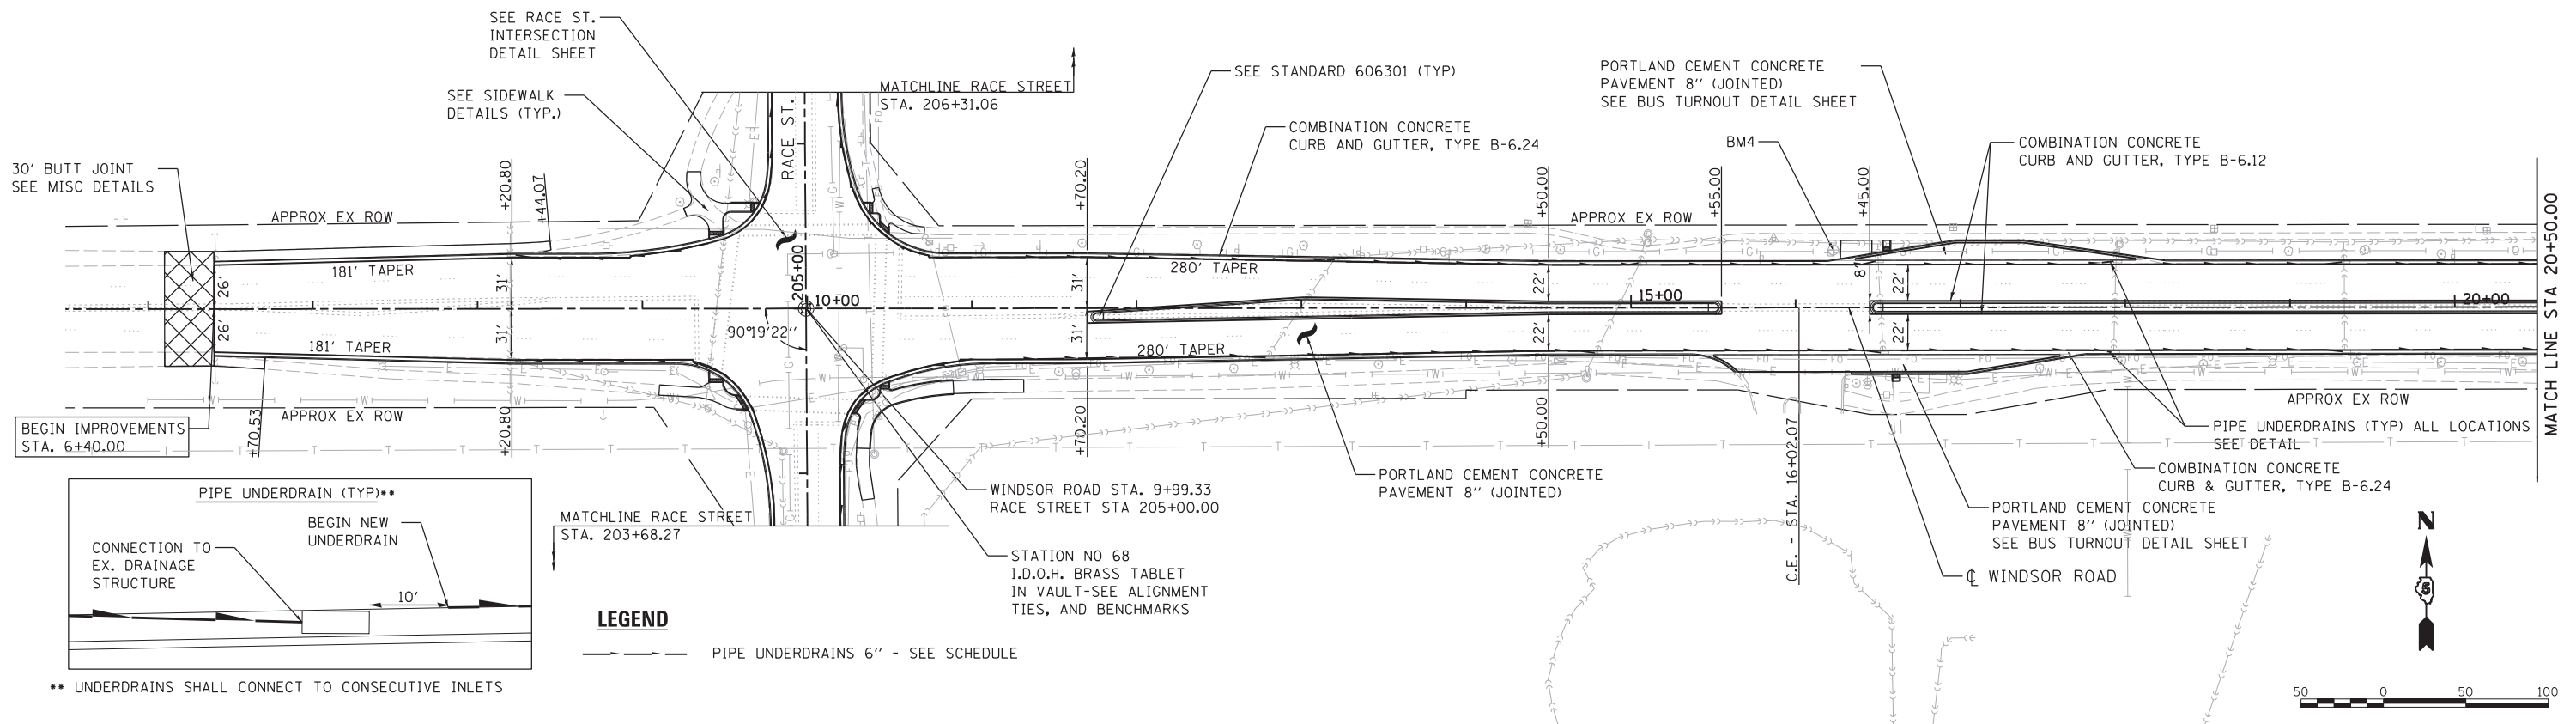

FILE NAME =	USER NAME = johns00944	DESIGNED - MH	REVISED -	STATE OF ILLINOIS DEPARTMENT OF TRANSPORTATION	PLAN & PROFILE - (WINDSOR RD.) WINDSOR ROAD	F.A.P. RTE.	SECTION	COUNTY	TOTAL SHEETS	SHEET NO.
D513L0201-shr-plnprf01		DRAWN - RSJ	REVISED -			7145	13-00540-00-PV	CHAMPAIGN	80	28
MODEL NAME = Plan and Profile		CHECKED - MH	REVISED -			13L0201		CONTRACT NO.	91515	
PLOT DATE = 06/12/2014		DATE = 05-03-2014	REVISED -			ILLINOIS FED. AID PROJECT				

PENTABLE NAME = ...C:\ProgramData\Bentley\MicroStation V8i (SELECTseries)\WorkSpace\pr\Bj02t68768\NAME.tbl...Plot\100T.pdf_680dpi.pltcf


PLAN	SURVEYED	BY	DATE
	PLOTTED		
	NOTE BOOK		
	NO.		
	ALIGNED		
	CHECKED		
	DATE		
	FILE NAME		



© Copyright Hanson Professional Services Inc. 2014


PROFILE	SURVEYED	BY	DATE
	PLOTTED		
	NOTE BOOK		
	NO.		
	GRADES CHECKED		
	STRUCTURE		
	NOTATIONS		
	CPAD		

DESIGNED	MH	4/29/14
DRAWN	RSJ	4/29/14
REVIEWED	MH	4/29/14

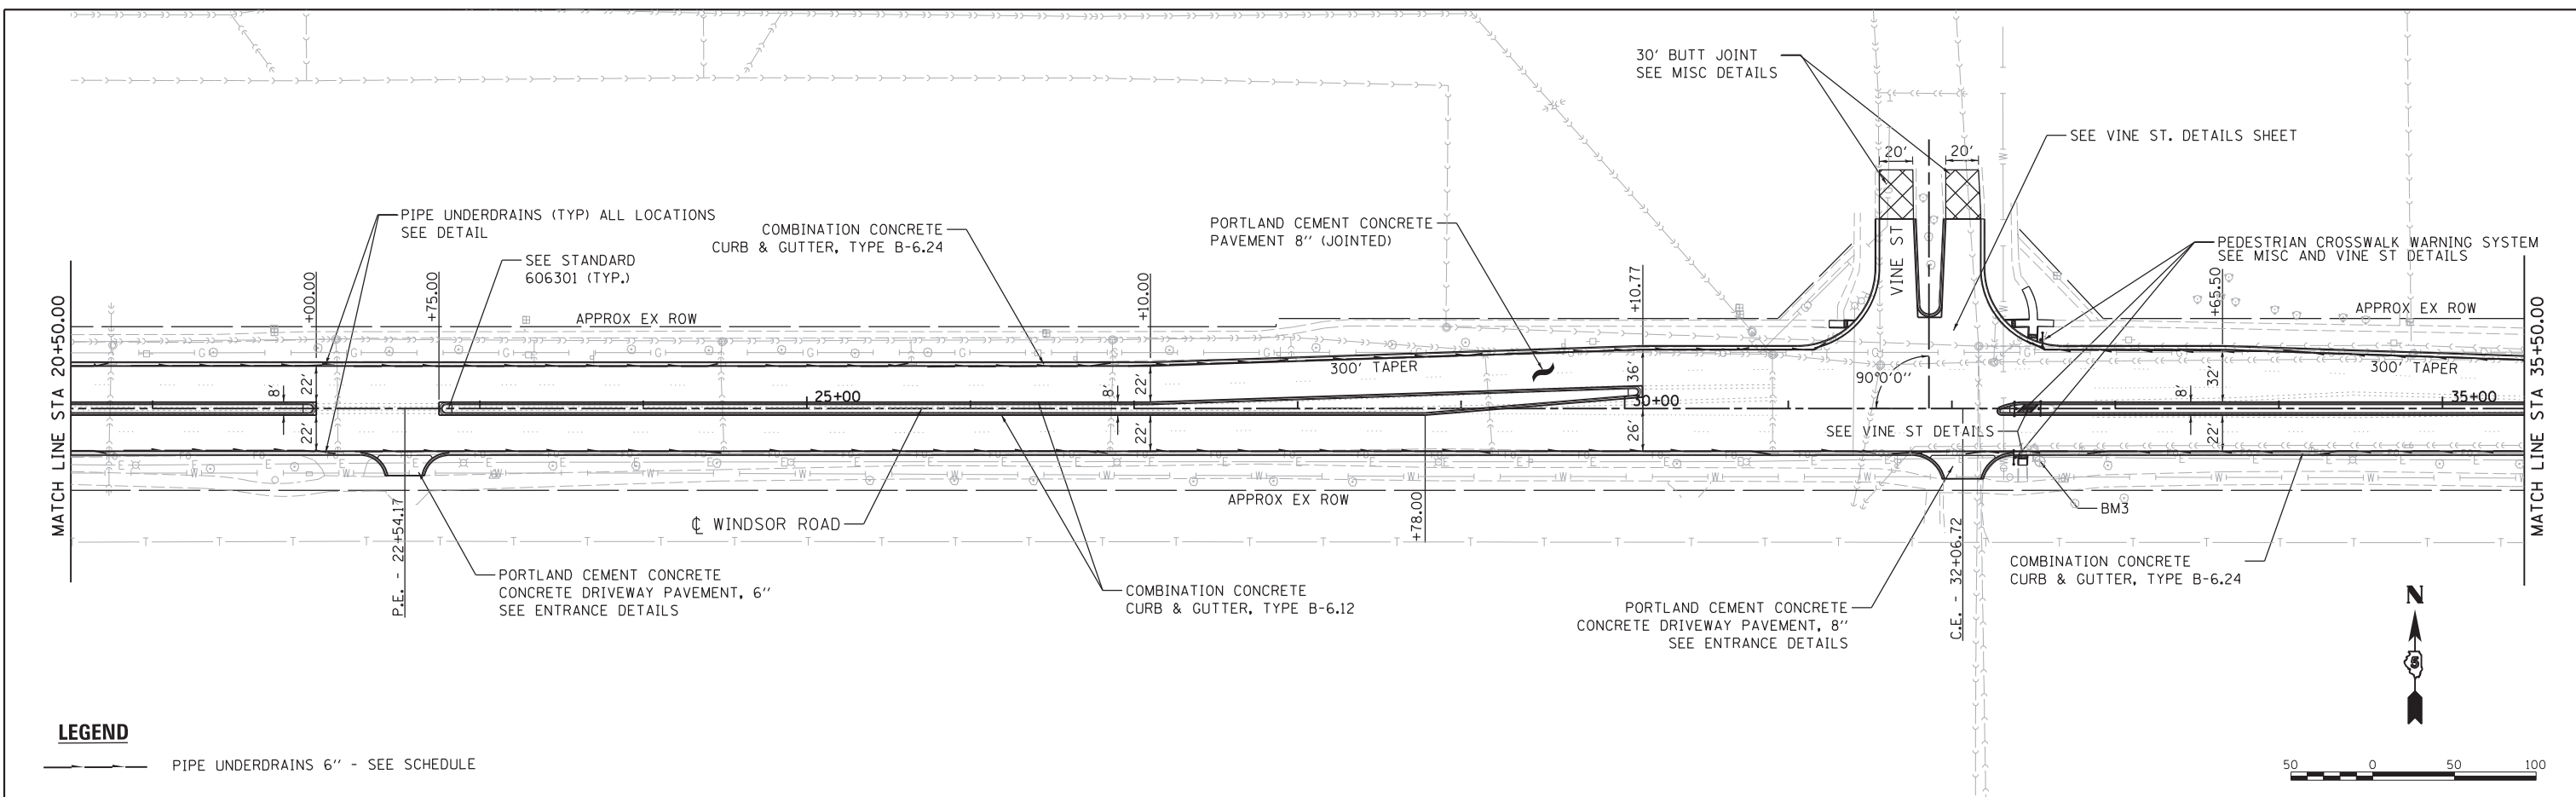

LEGEND

PIPE UNDERDRAINS 6" - SEE SCHEDULE

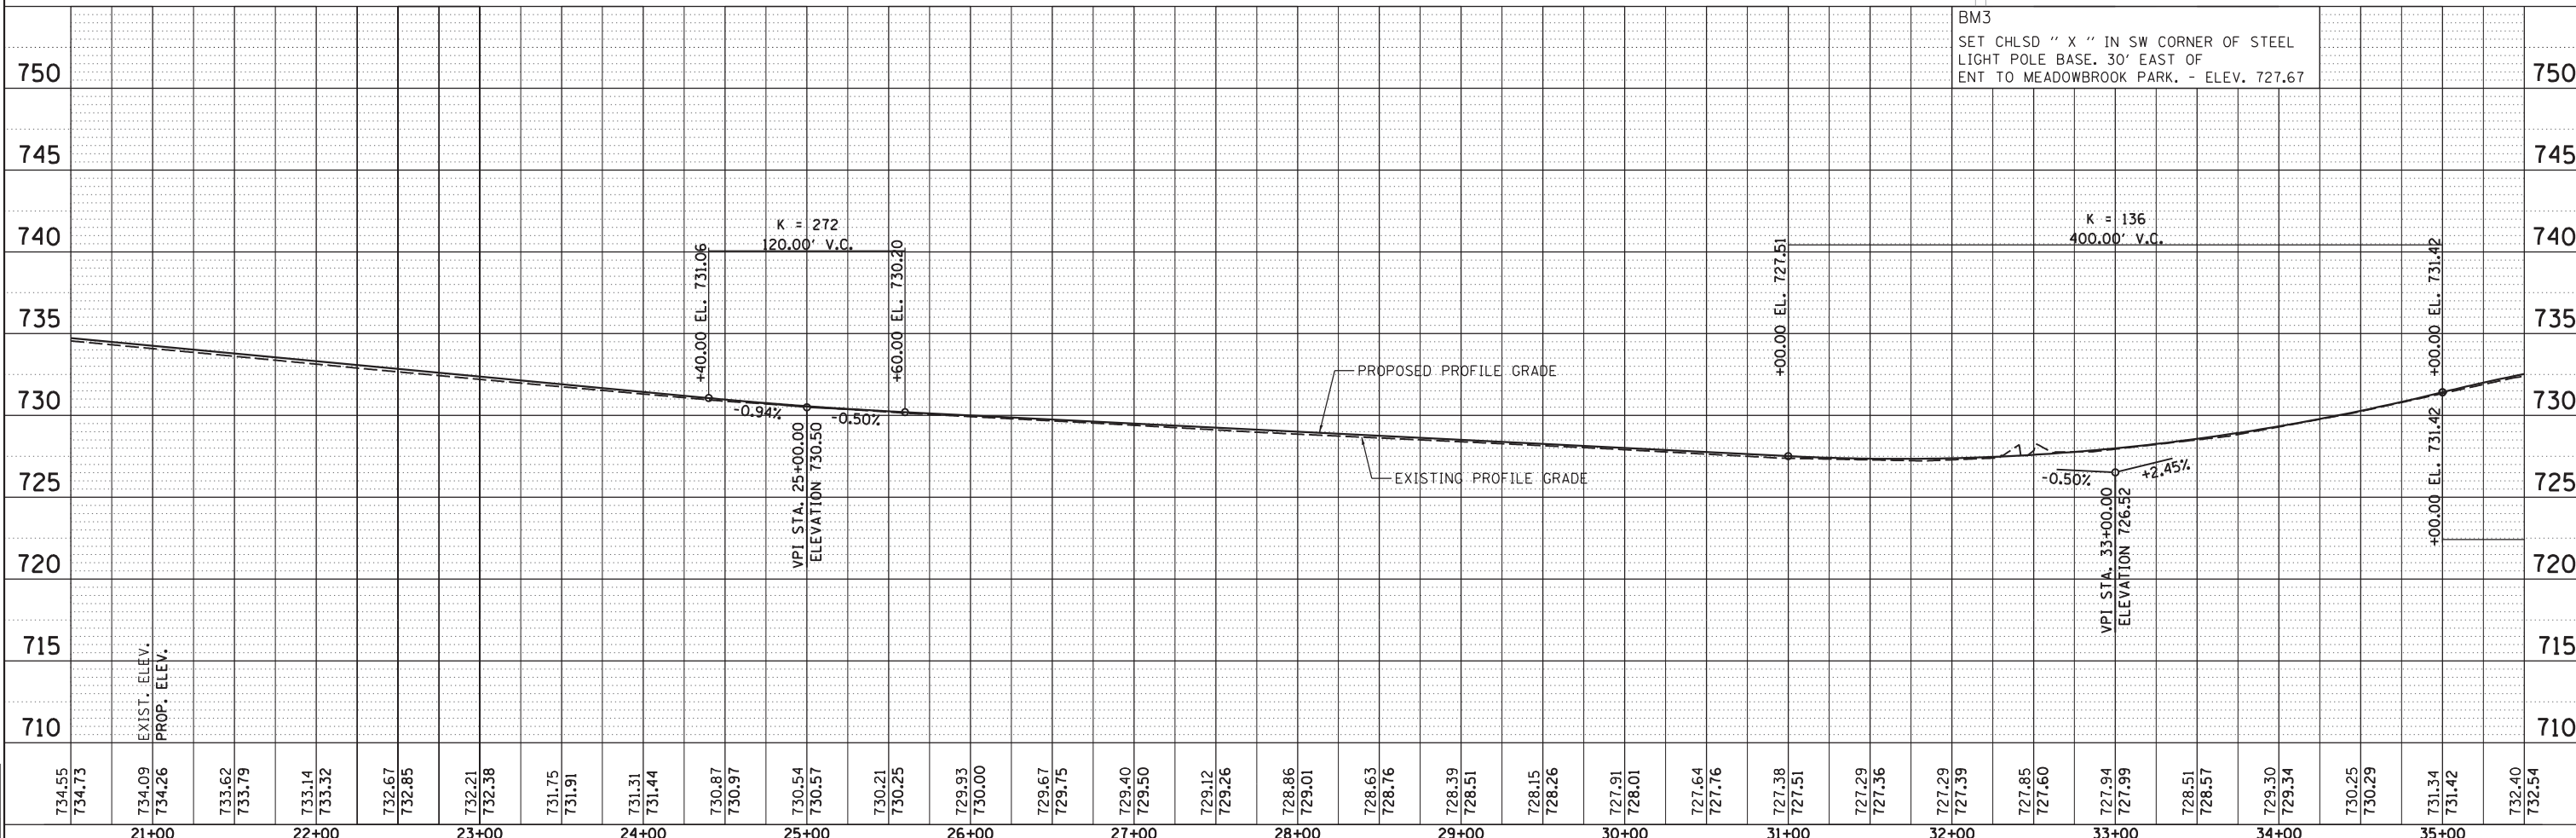

FILE NAME =	USER NAME = johns00944	DESIGNED - MH	REVISED -	<p align="center">STATE OF ILLINOIS DEPARTMENT OF TRANSPORTATION</p> <p align="center">PLAN & PROFILE - (WINDSOR RD.) WINDSOR ROAD</p> <p>SCALE: 1" = 50' SHEET 2 OF 4 SHEETS STA. TO STA.</p>	F.A.P. RTE. 7145	SECTION 13-00540-00-PV	COUNTY CHAMPAIGN	TOTAL SHEETS 80	SHEET NO. 29
D513L0201-shr-plnprf02		DRAWN - RSJ	REVISED -		13L0201		CONTRACT NO. 91515		
MODEL NAME = Plan and Profile		CHECKED - MH	REVISED -		ILLINOIS FED. AID PROJECT				
PLOT DATE = 06/12/2014		DATE = 05-03-2014	REVISED -						


PENTABLE NAME = ...C:\ProgramData\Bentley\MicroStation V8i (SELECTseries)\Workspace\pr\Bj0268768\NAME.tbl...Plot\100T.pdf_600dpi.pltcf

PLAN	SURVEYED	BY	DATE
	PLOTTED		
	NOTE BOOK		
	NO.		



PROFILE	SURVEYED	BY	DATE
	PLOTTED		
	NOTE BOOK		
	NO.		

DESIGNED	MH	4/29/14
DRAWN	RSJ	4/29/14
REVIEWED	MH	4/29/14

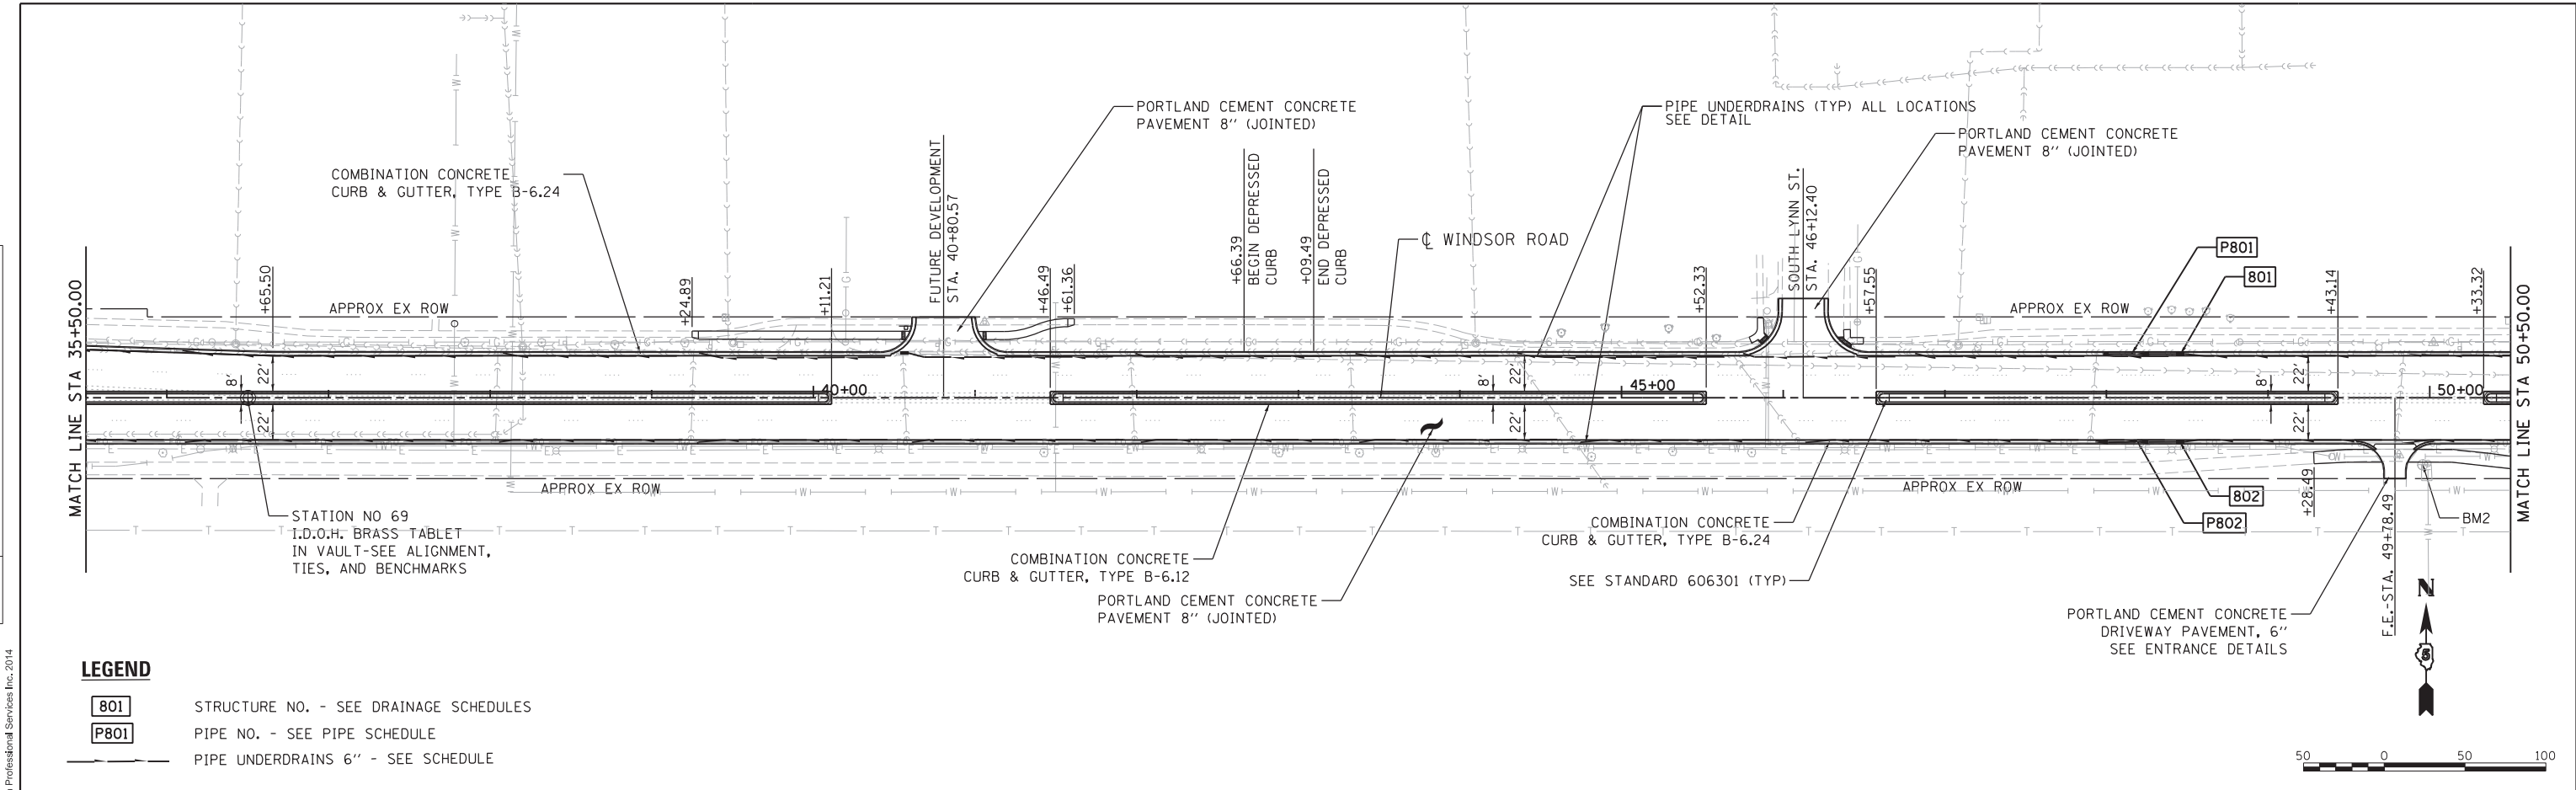


LEGEND

801 STRUCTURE NO. - SEE DRAINAGE SCHEDULES

P801 PIPE NO. - SEE PIPE SCHEDULE

PIPE UNDERDRAINS 6" - SEE SCHEDULE

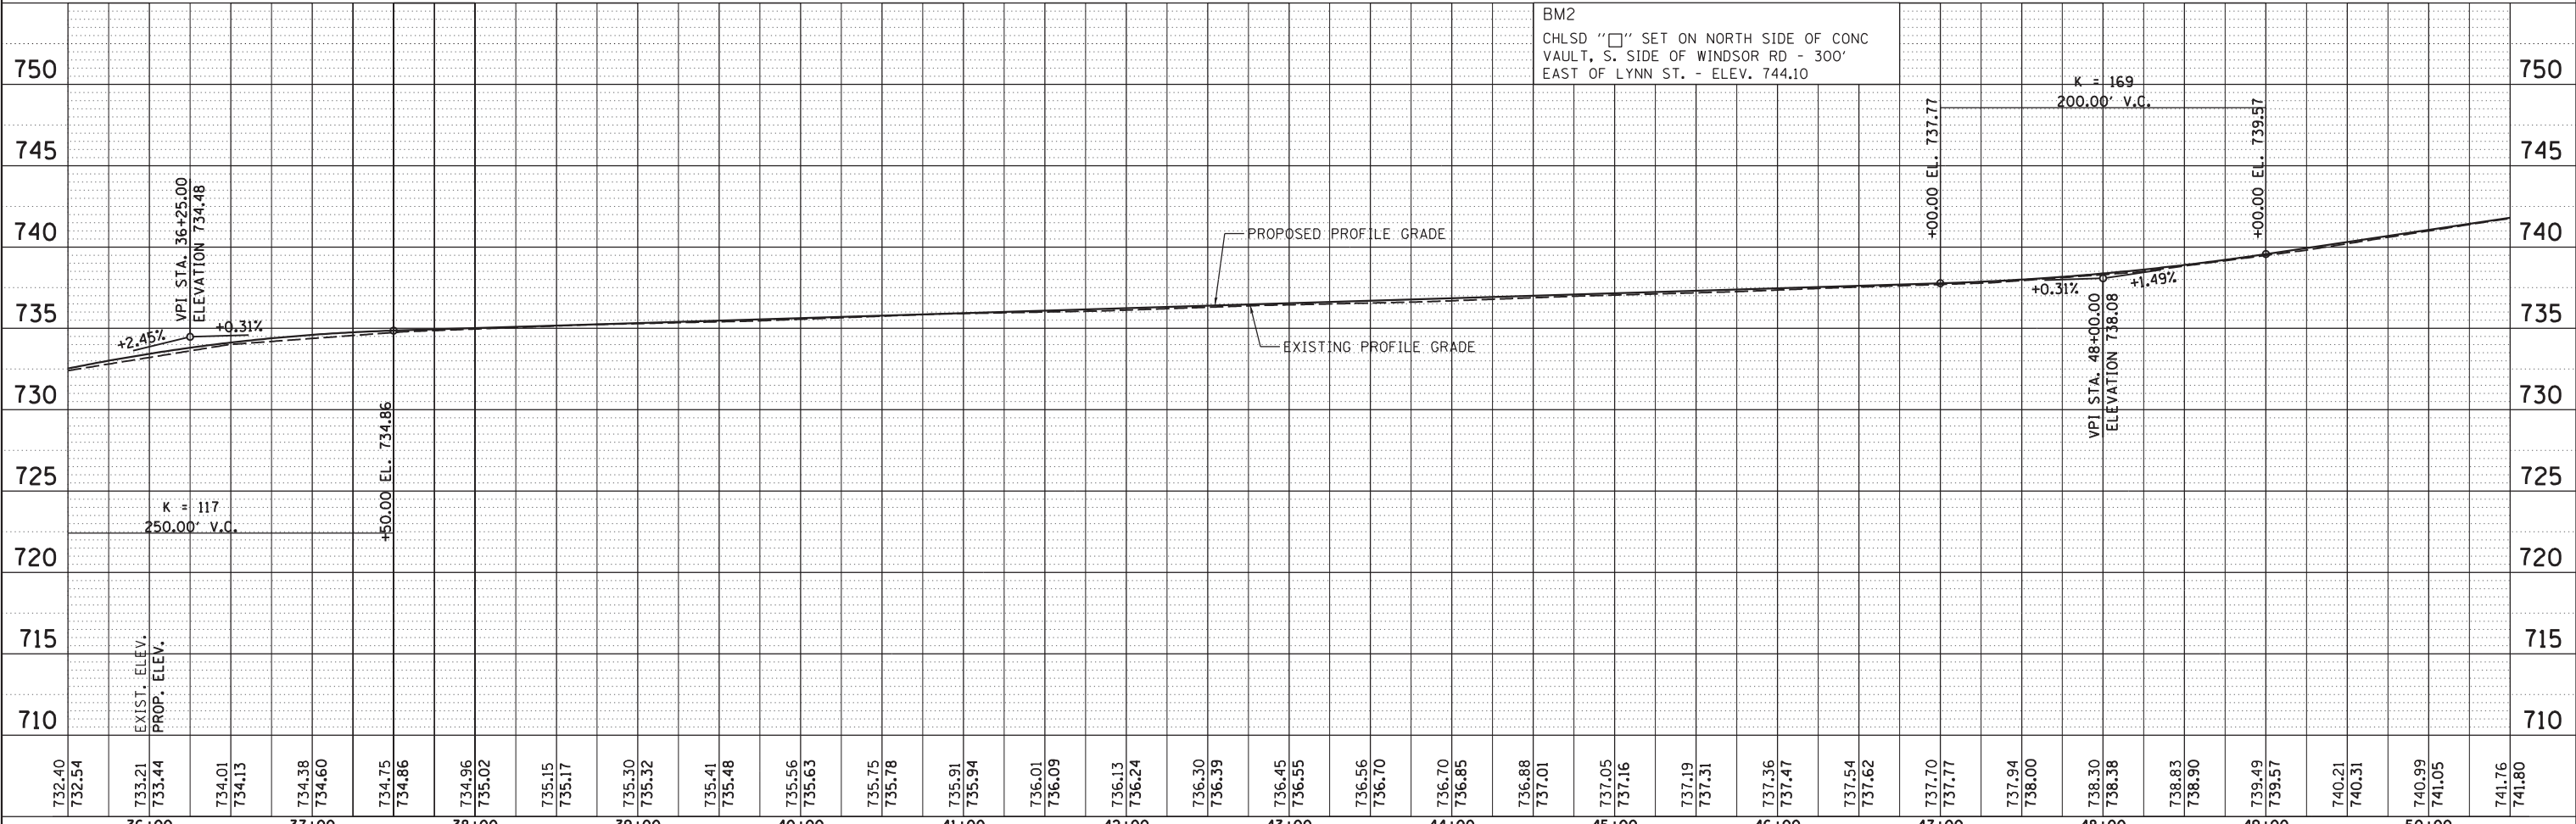

FILE NAME =	USER NAME =	DESIGNED -	REVISED -	<p align="center">STATE OF ILLINOIS DEPARTMENT OF TRANSPORTATION</p> <p align="center">PLAN & PROFILE - (WINDSOR RD.) WINDSOR ROAD</p>	F.A.P. RTE.	SECTION	COUNTY	TOTAL SHEETS	SHEET NO.
D513L0201-sht-plnprf03	pop00275	DRAWN -	REVISED -		7145	13-00540-00-PV	CHAMPAIGN	80	30
MODEL NAME =	PLOT SCALE =	CHECKED -	REVISED -		13L0201		CONTRACT NO.	91515	
Plan and Profile	100.0000' / in.	DATE =	REVISED -		SCALE: 1" = 50'		SHEET 3 OF 4 SHEETS		STA. TO STA.

PENTABLE NAME = ...C:\ProgramData\Bentley\MicroStation V8i (SELECTseries)\Workspace\prj\02\689768\NAME.tbl...Plot\DDOT.pdf_680dpi.pltcf


PLAN	SURVEYED	DATE
	PLOTTED	BY
	ALIGNED	
	CHECKED	
	FILED	
	NO.	



© Copyright Hanson Professional Services Inc. 2014


PROFILE	SURVEYED	DATE
	PLOTTED	BY
	GRADES CHECKED	
	STRUCTURE NOTATIONS OK'D	
	NO.	

DESIGNED	MH	4/29/14
DRAWN	RSJ	4/29/14
REVIEWED	MH	4/29/14

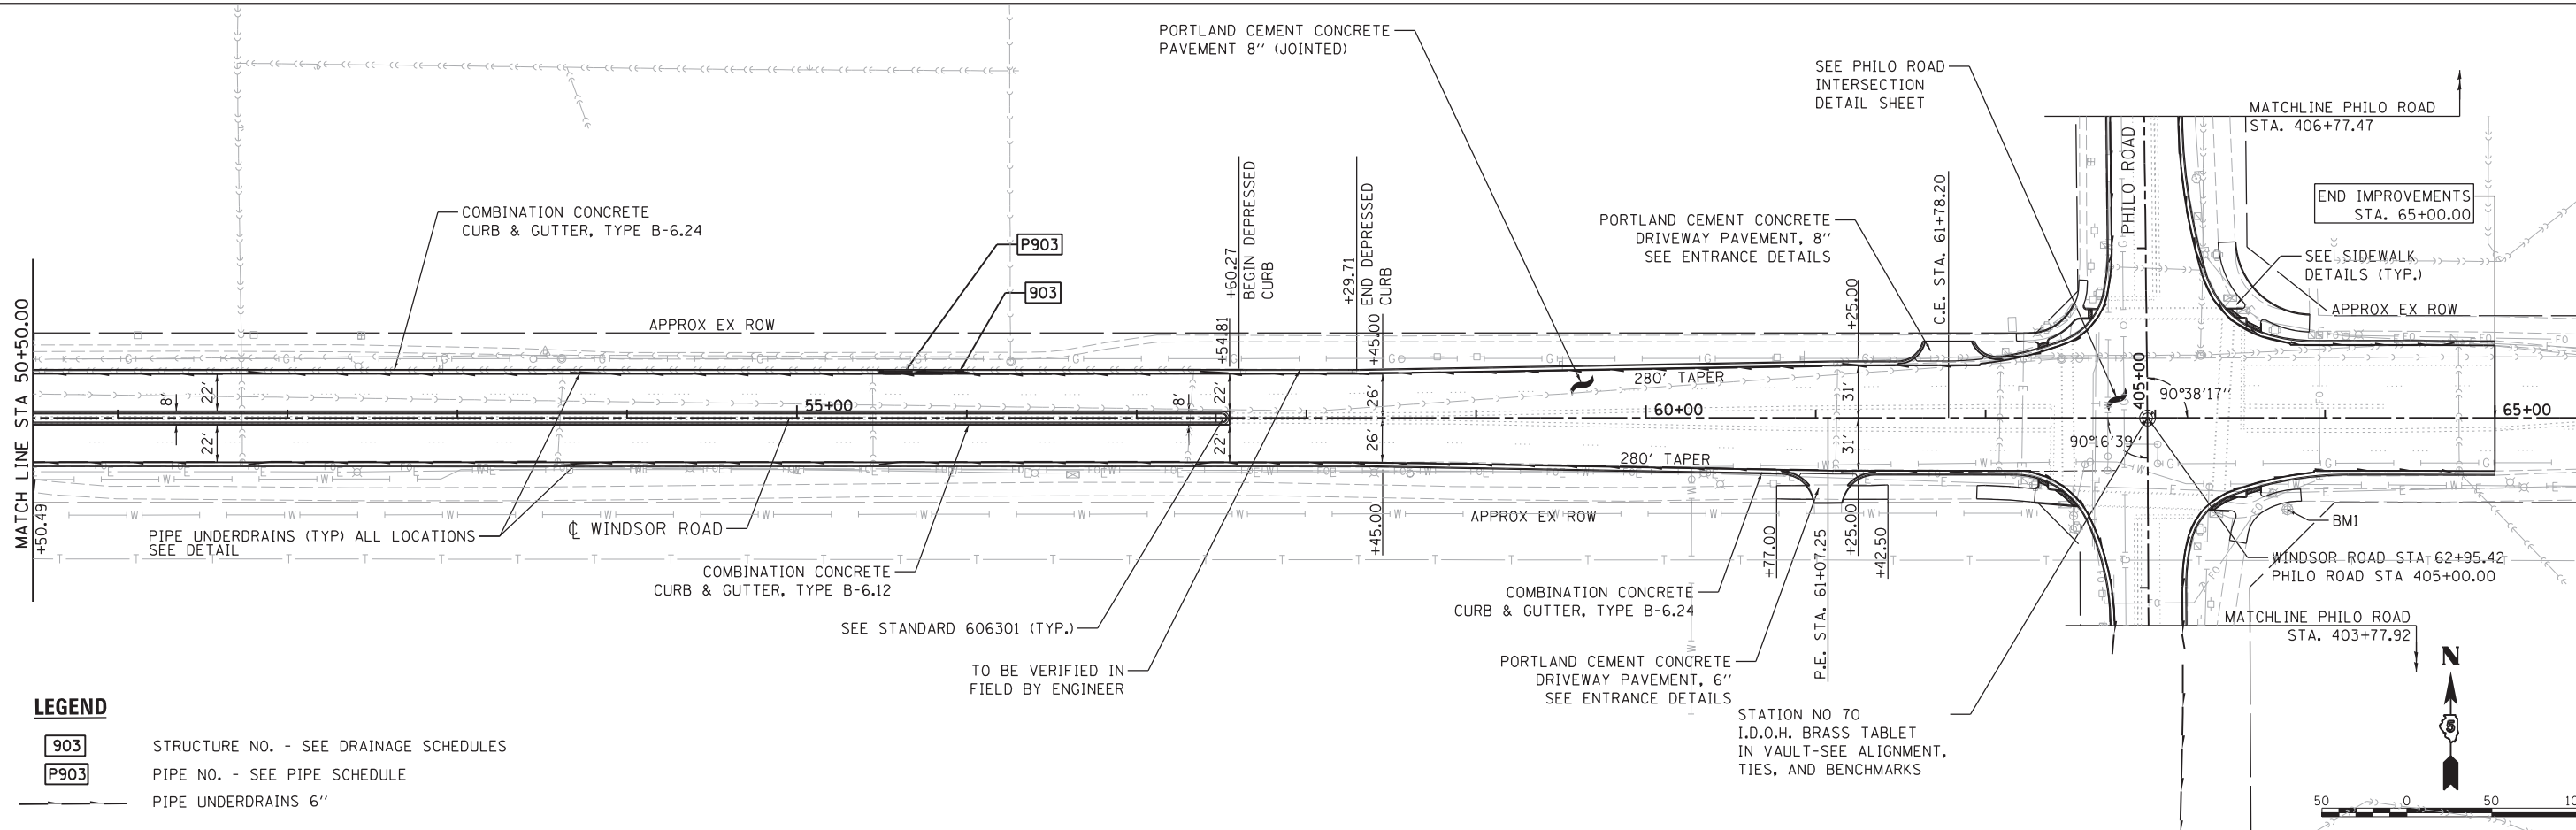

LEGEND

- 903 STRUCTURE NO. - SEE DRAINAGE SCHEDULES
- P903 PIPE NO. - SEE PIPE SCHEDULE
- PIPE UNDERDRAINS 6"

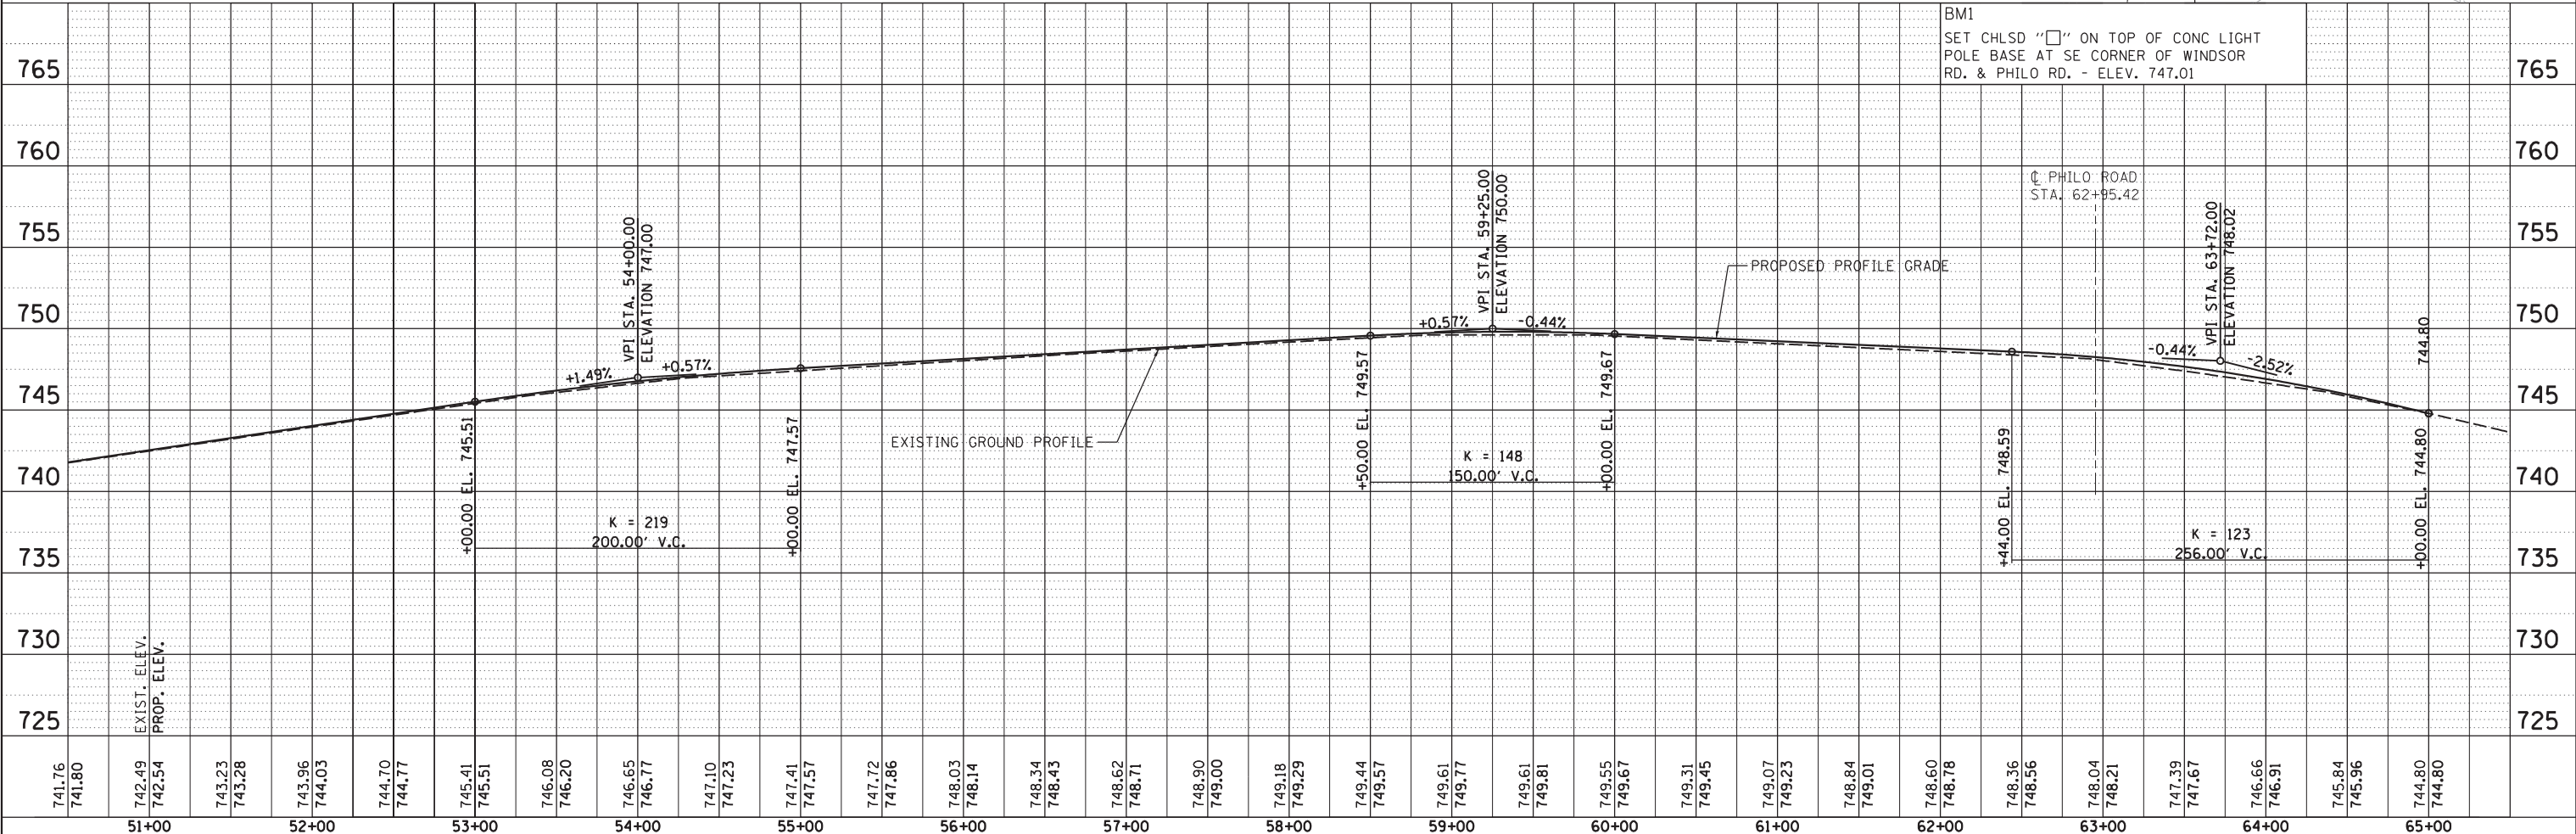

FILE NAME =	USER NAME = johns00944	DESIGNED - MH	REVISED -	STATE OF ILLINOIS DEPARTMENT OF TRANSPORTATION	PLAN & PROFILE - (WINDSOR RD.) WINDSOR ROAD	F.A.P. RTE.	SECTION	COUNTY	TOTAL SHEETS	SHEET NO.
D513L0201-sht-plnprf04		DRAWN - RSJ	REVISED -			7145	13-00540-00-PV	CHAMPAIGN	80	31
MODEL NAME =		CHECKED - MH	REVISED -			13L0201		CONTRACT NO.	91515	
Plan and Profile		DATE = 05-03-2014	REVISED -			ILLINOIS FED. AID PROJECT				

PENTABLE NAME = ...C:\ProgramData\Bentley\MicroStation V8i (SELECTseries)\Workspace\pr\04\05\05\13L0201\13L0201.dwg